



FOR CONSTRUCTION - JUNE 2025

SHEET	DESCRIPTION
<u>GENERAL</u>	
G-001	COVER, DRAWING INDEX, LOCATION AND VICINITY MAP
G-002	DESIGN CRITERIA, PIPE SCHEDULE, AND COMMON SYMBOLS
<u>INSTRUMENTATION</u>	
I-001	SYMBOLS AND NOMENCLATURE - I
I-002	SYMBOLS AND NOMENCLATURE - II
I-003	SYMBOLS AND NOMENCLATURE - III
I-004	SYMBOLS AND NOMENCLATURE - IV
I-005	INSTALLATION DETAILS - I
I-006	EXISTING PN-1011 RAS/WAS INTERNAL PLC LAYOUT
I-601	WAS PUMPS P&ID
<u>PROCESS</u>	
D-001	GENERAL NOTES AND STANDARD DETAIL
DD901	WAS PUMP STATION DEMOLITION PICTURES
DD902	SCUM PUMP STATION DEMOLITION PICTURES
D-101	PUMP STATION PLAN
D-102	SCUM PUMP STATION PLAN AND SECTION
D-301	PUMP STATION SECTIONS - I
D-302	PUMP STATION SECTIONS - II
D-901	PUMP STATION ISOMETRIC VIEWS
<u>ELECTRICAL</u>	
E-101	SITE PLAN
E-102	PUMP STATION PLAN AND SCHEDULE



AJ THORN
PUBLIC WORKS DIRECTOR
39250 PIONEER BLVD
SANDY, OR 97055
AJTHORNE@CI.SANDY.OR.US
PHONE: 503-489-2162



LOCATION MAP



VICINITY MAP

PROJECT NUMBER: 2002006370

\\users\shafzal\dc\accdocs\stantec consulting\2002006267_sandy_scwp\project files\was_scum\01_wip\08_ic\sheet_files\i-002

Permit/Seal

REGISTERED PROFESSIONAL
ENGINEER
77866 PE
OREGON
DEC. 12, 2012
ADAM I. ODELL
EXPIRES: 12-31-26

Client/Project
CITY OF SANDY

WASTE SLUDGE AND SCUM
PUMP REPLACEMENT
PROJECT
Sandy, OR

Project No.: 2002006370			
File Name: F002			
Scale: NO SCALE			
SNA	PMA	2025.04.25	
Dwn.	Dsgn.	Chkd.	YYYY-MM-DD
Title			
SYMBOLS AND			
NOMENCLATURE - II			
Revision:		Sheet:	of
Drawing No.			

I-002

I-002

c:\users\shafzal\dc\accdocs\stantec consulting\2002006267_sandy_scwp\project files\was_scum\01_wip\08_ic\sheet_files\i-004

C:\Users\jstevens\Documents\stntec\consulting\000200627_sandy_lowndr\project\Rev\revs\0001\0001001.dwg 11/14/2023 4:45 PM
2023/02/14 4:45:15 AM

A

B

C


D

BILL OF MATERIALS				
ITEM	QTY	DESCRIPTION	SUPPLY	MATERIAL/RATING (WATER) MATERIAL/RATING (CHEMICAL)
1	1	AWG # 8 GROUNDING CONDUCTOR TO GROUND GRID	CONT	COPPER COPPER
2	2	GROUNDING RING	MANF	316 SS (G) 316 SS OR HASTELLOY C (G)
3	1	INTEGRAL TRANSMITTER WITH DISPLAY AND DUAL CONDUIT PORTS	MANF	POWDER COATED ALUMINUM POWDER COATED ALUMINUM
4	1	REMOTE TRANSMITTER WITH DISPLAY	MANF	POWDER COATED ALUMINUM POWDER COATED ALUMINUM
5	1	METER REMOTE WIRE HOUSING FOR REMOTE TRANSMITTER WITH DUAL CONDUIT PORTS	MANF	POWDER COATED ALUMINUM POWDER COATED ALUMINUM
6	1 EACH	COIL DRIVE AND ELECTRODE SIGNAL CABLES (SEPARATE CABLES; LENGTH AS REQUIRED)	CONT	PER MANF SPEC PER MANF SPEC
7	-	METER MEASURING TUBE / FLANGES (LINER PER MANF RECOMMENDATION)	MANF	304 SS (F)
8	2	INSULATING GASKET	CONT	EPDM / NEOPRENE EPDM / NEOPRENE


I-101 MAGNETIC FLOW METER

REV 010119

- GENERAL NOTES:**
- REFER TO P&IDS AND DATA SHEETS FOR PROCESS PIPING SIZE AND MATERIAL.
 - BIDIRECTIONAL APPLICATION REQUIRES 5 PIPE DIAMETERS ON BOTH SIDES OF METER. MINIMUM UNIDIRECTIONAL APPLICATION REQUIRES 5 PIPE DIAMETERS UPSTREAM AND 2 PIPE DIAMETERS DOWNSTREAM WITH STABLE PROCESS CONDUCTIVITY.
 - WETTED MATERIALS SHALL BE CHEMICALLY INERT TO THE PROCESS.
 - INSTALLATION OF MATING FLANGES WITH THE FLOW METER SHALL BE CARRIED OUT IN COOPERATION WITH THE PIPING CONTRACTOR USING UPSTREAM AND DOWNSTREAM PIPE REDUCERS AS NECESSARY.
 - PROVIDE MECHANICAL SUPPORT FOR ROUTED CONDUIT.
 - REFER TO DIVISION 26 SPECIFICATIONS FOR FLEX AND RIGID CONDUIT MATERIAL AND USAGE LIMITATIONS.
- KEYNOTES:**
- GROUNDING RINGS REQUIRED FOR METALLIC AND NON-METALLIC PIPE INSTALLATIONS TO SUPPORT PROPER SOLUTION GROUNDING AND / OR LINING PROTECTION.
 - WALL OR INSTRUMENT-STAND MOUNT PER DETAIL I-948.
 - CONFIGURE FOR EMPTY PIPE DETECTION.
 - WHERE TEMPORARY SUBMERGENCE IS POSSIBLE, ELECTRONIC HOUSING SHALL BE POTTED AND SEALED BY MANUFACTURER PRIOR TO SHIPPING TO SITE.
 - CONTRACTOR TO ISOLATE METER FROM THE PIPELINE USING ISOLATION WASHERS AND SLEEVES ON FLANGE BOLTS.
 - 316 SS OR HASTELLOY C PREFERRED. HOWEVER ENGINEER APPROVED FINAL SELECTION BASED ON MATERIAL CHEMICAL COMPATIBILITY.
 - SELECTED GROUNDING RING MATERIAL TO MATCH MEASURING ELECTRODE MATERIAL.
 - FOR INSTALLATION WITHIN CATHODIC PROTECTION SYSTEMS, USE NON-METALLIC LIQUIDTIGHT FLEXIBLE CONDUIT.
 - DISCONNECT COIL SIGNAL SHIELD WIRE AT THE REMOTE TRANSMITTER.

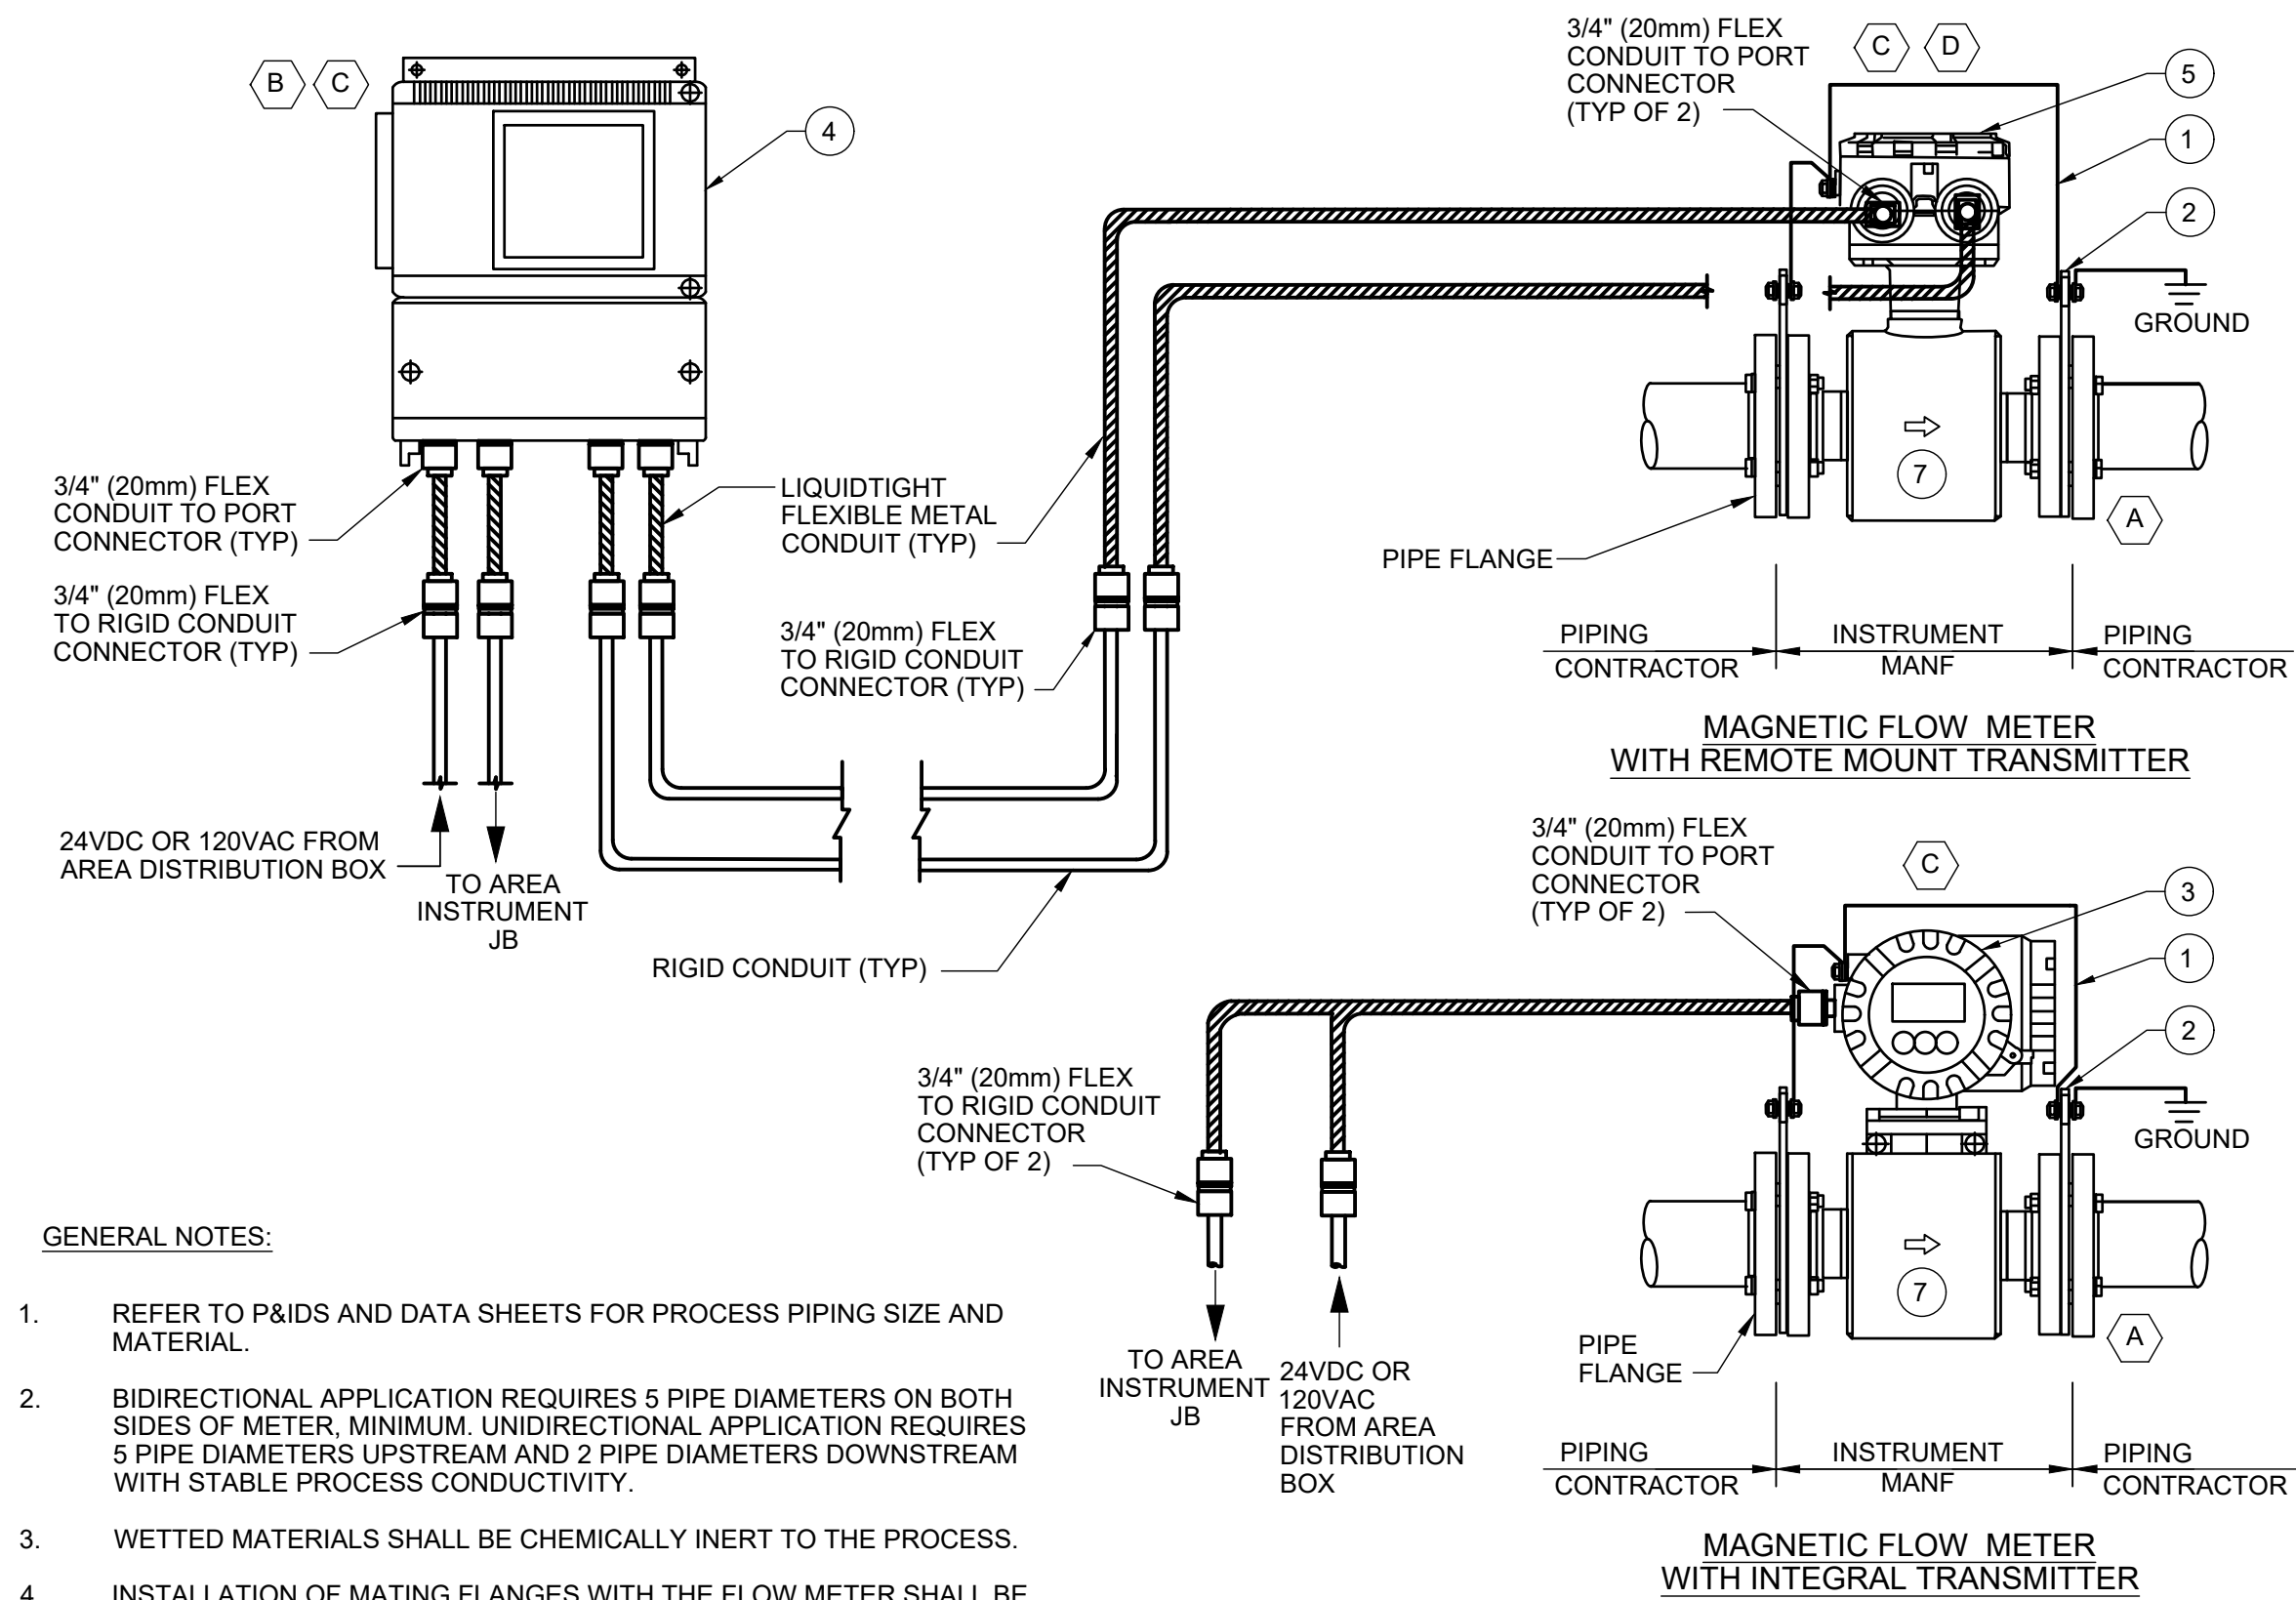


MAGNETIC FLOW METER WITH REMOTE MOUNT TRANSMITTER (FOR CATHODIC PIPE PROTECTION APPLICATION)

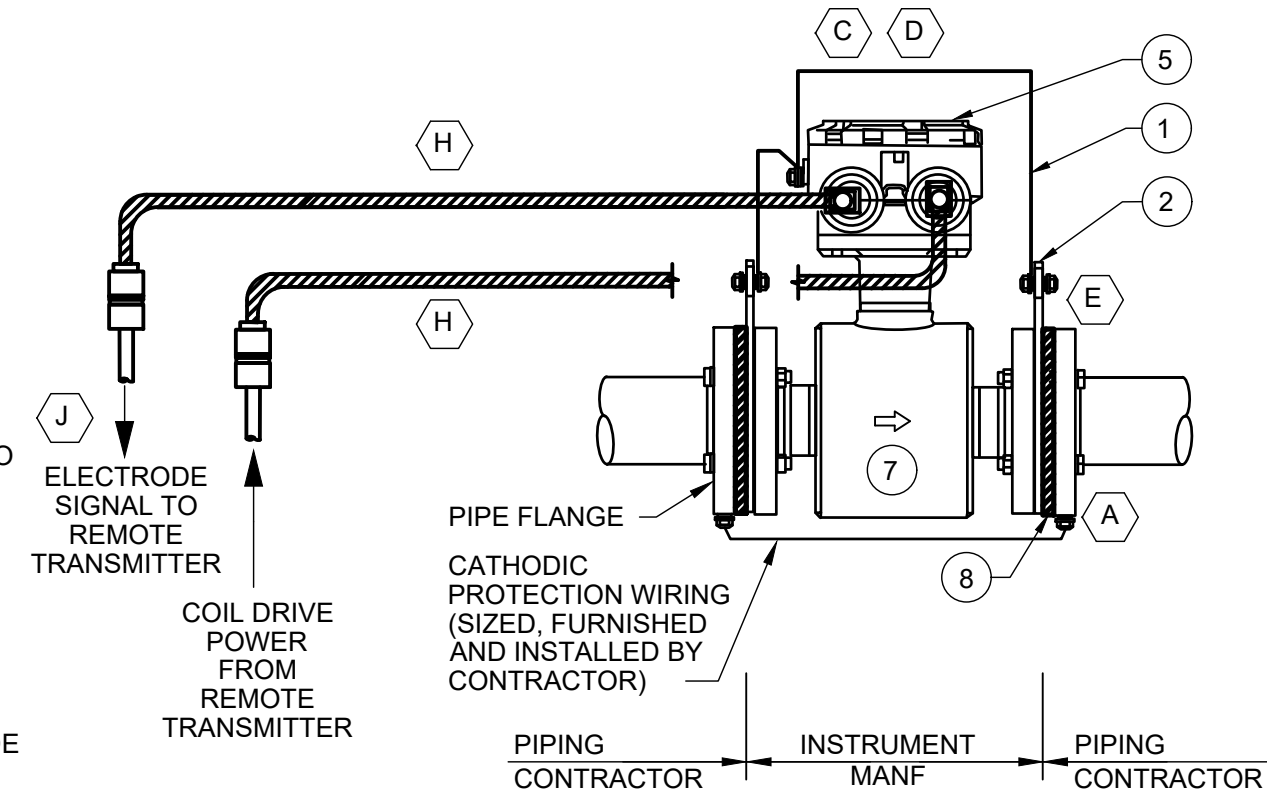

BILL OF MATERIALS				
ITEM	QTY	DESCRIPTION	SUPPLY	MATERIAL/ RATING (WATER / AIR) MATERIAL/ RATING (CHEMICAL)
1	1	LIQUID-FILLED PRESSURE GAUGE	MANF	PHENOLIC ENCASED PHENOLIC ENCASED
2	1	1/2" (15mm) 2 VALVE MANIFOLD WITH INTEGRAL BLEED	MANF	316 SS 316 SS OR PVC
3	AR	ISOLATION DIAPHRAGM SEAL; SILICONE OIL FILL FLUID (A)	MANF	316 SS HASTELLOY C OR PVC
4	1	HEX REDUCING BUSHING 1"x1/2" (25mmx15mm)	CONT	316 SS 316 SS OR PVC
5	2	END FLANGES (CLASS TO SUIT PIPING)	MANF	EPOXY COATED CARBON STEEL 316 SS OR PVC
6	1	1/4" NPT VENT PIPE PLUG (B)	MANF	316 SS 316 SS OR PVC
7	1	PRESSURE SWITCH	MANF	316 SS 316 SS OR PVC
8	1	TEE 1/2" (15mm)	CONT	316 SS 316 SS OR PVC
9	2	ELBOW 1/2" (15mm)	CONT	316 SS 316 SS OR PVC
10	AR	1/2" MALE TO MALE NIPPLE	CONT	316 SS 316 SS OR PVC
11	2	GASKETS	CONT	VITON VITON
12	1	ANNULAR SEAL; SILICONE OIL FILL FLUID (A)	MANF	TEFLON COATED BUNA-N PTFE OR TEFLON COATED VITON
13	1	INSTRUMENT REMOVAL DEVICE AND 1/2" STEM	MANF	316 SS 316 SS OR PVC

I-301 PRESSURE GAUGE / SWITCH


REV 010119

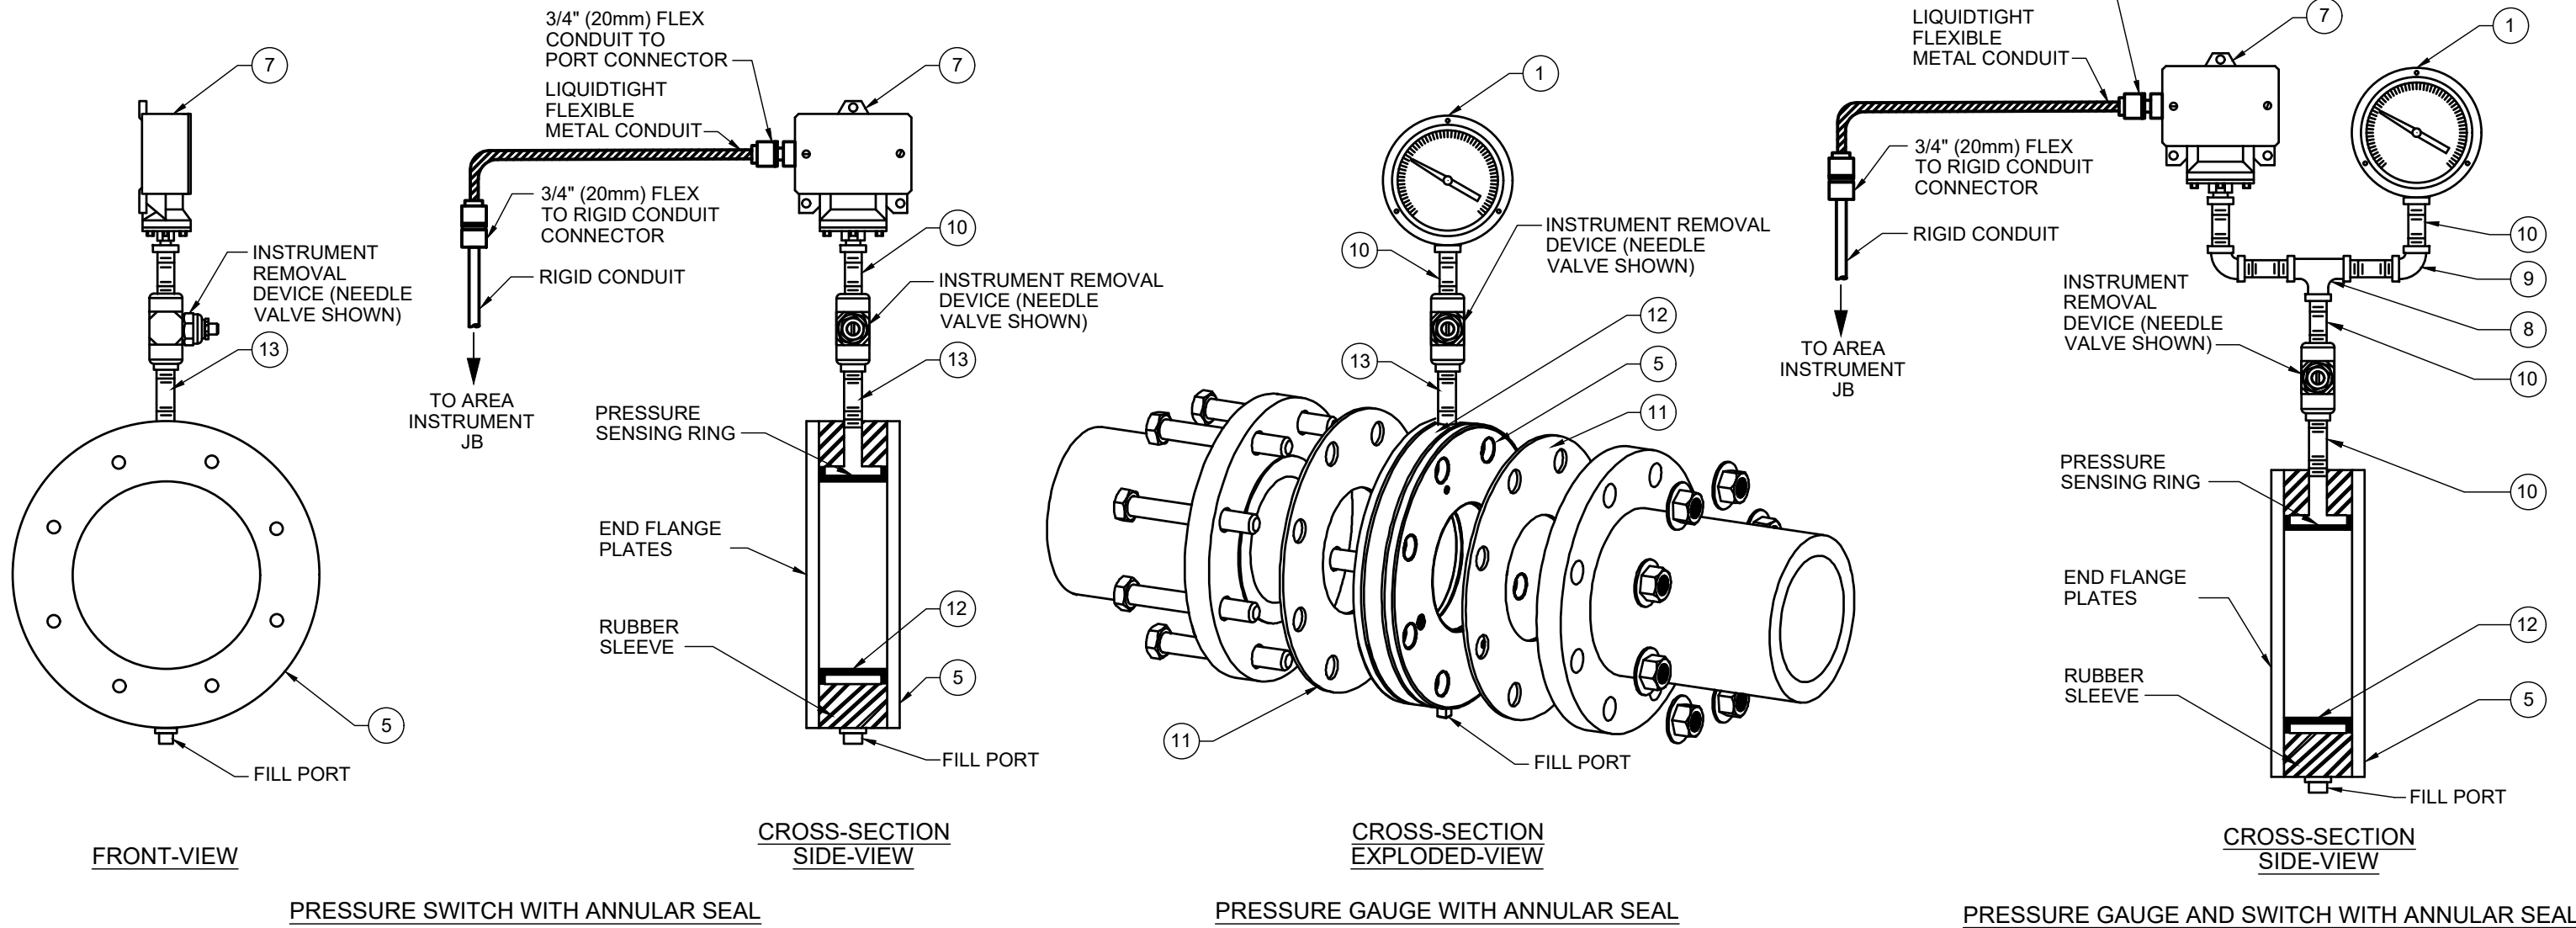

- GENERAL NOTES:**
- POTENTIALLY WETTED MATERIALS SHALL BE CHEMICALLY INERT TO THE PROCESS.
 - REFER TO P&IDS AND DATA SHEETS FOR PROCESS PIPING SIZE AND MATERIAL.
 - PIPING SIDE ISOLATION VALVES FURNISHED AND INSTALLED BY MECHANICAL CONTRACTOR.
 - REFER TO DIVISION 26 SPECIFICATIONS FOR FLEX AND RIGID CONDUIT MATERIAL AND USAGE LIMITATIONS.
- KEYNOTES:**
- FOR AMBIENT TEMPERATURE APPLICATIONS LOWER THAN -10 degC, ETHYLENE GLYCOL FILL FLUID REQUIRED IN LIEU OF STANDARD SILICONE OIL.
 - FURNISH 1/4" (8mm) OD MALE CONNECTOR AND 1/4" OD (1.5mm WALL THICKNESS) 316SS DOWN TURNED DRAIN TUBING FOR FIELD INSTALLATION. ENSURE VENT / DRAIN IS DIRECTED TO SAFE LOCATION.

Consultant

Permit/Seal

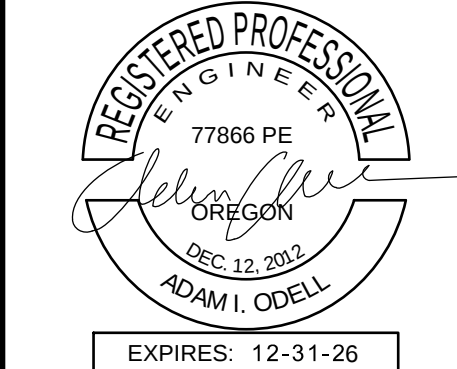

Client/Project
CITY OF SANDY

WASTE SLUDGE AND SCUM
PUMP REPLACEMENT
PROJECT
Sandy, OR

Project No.: 2002006370
File Name: I-005
Scale: NO SCALE
SNA PMA 2025.04.25
Dwn. Dsgn. Chkd. YYYY.MM.DD
Title
INSTALLATION DETAILS - I


Revision: Sheet: of
Drawing No.

I-005

Stantec

Stantec
401 SW 2nd Ave Suite 1400
Portland, Oregon, 97204
Tel: +1.503.226.7377
www.stantec.com

The Contractor shall verify and be responsible for all dimensions. DO NOT scale the drawing. The Contractor shall verify and be responsible for all dimensions. DO NOT scale the drawing. The Contractor shall verify and be responsible for all dimensions. DO NOT scale the drawing.

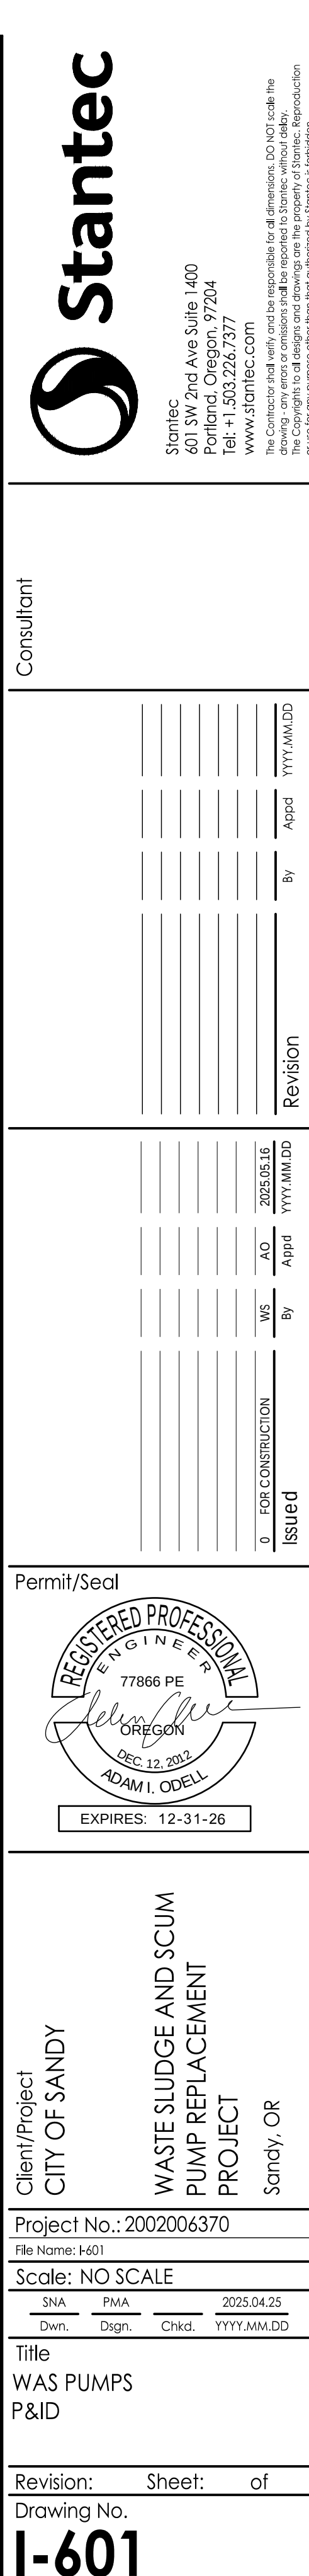

GENERAL SHEET NOTES

1. CONNECT PIPING FROM RAS PUMP TO WAS PIPING PRIOR TO REMOVAL OF WAS SYSTEM. SEE SHEET D-101.
2. FIELD RELOCATE WATER HEATER, PIPING, AND ALL ELECTRICAL.

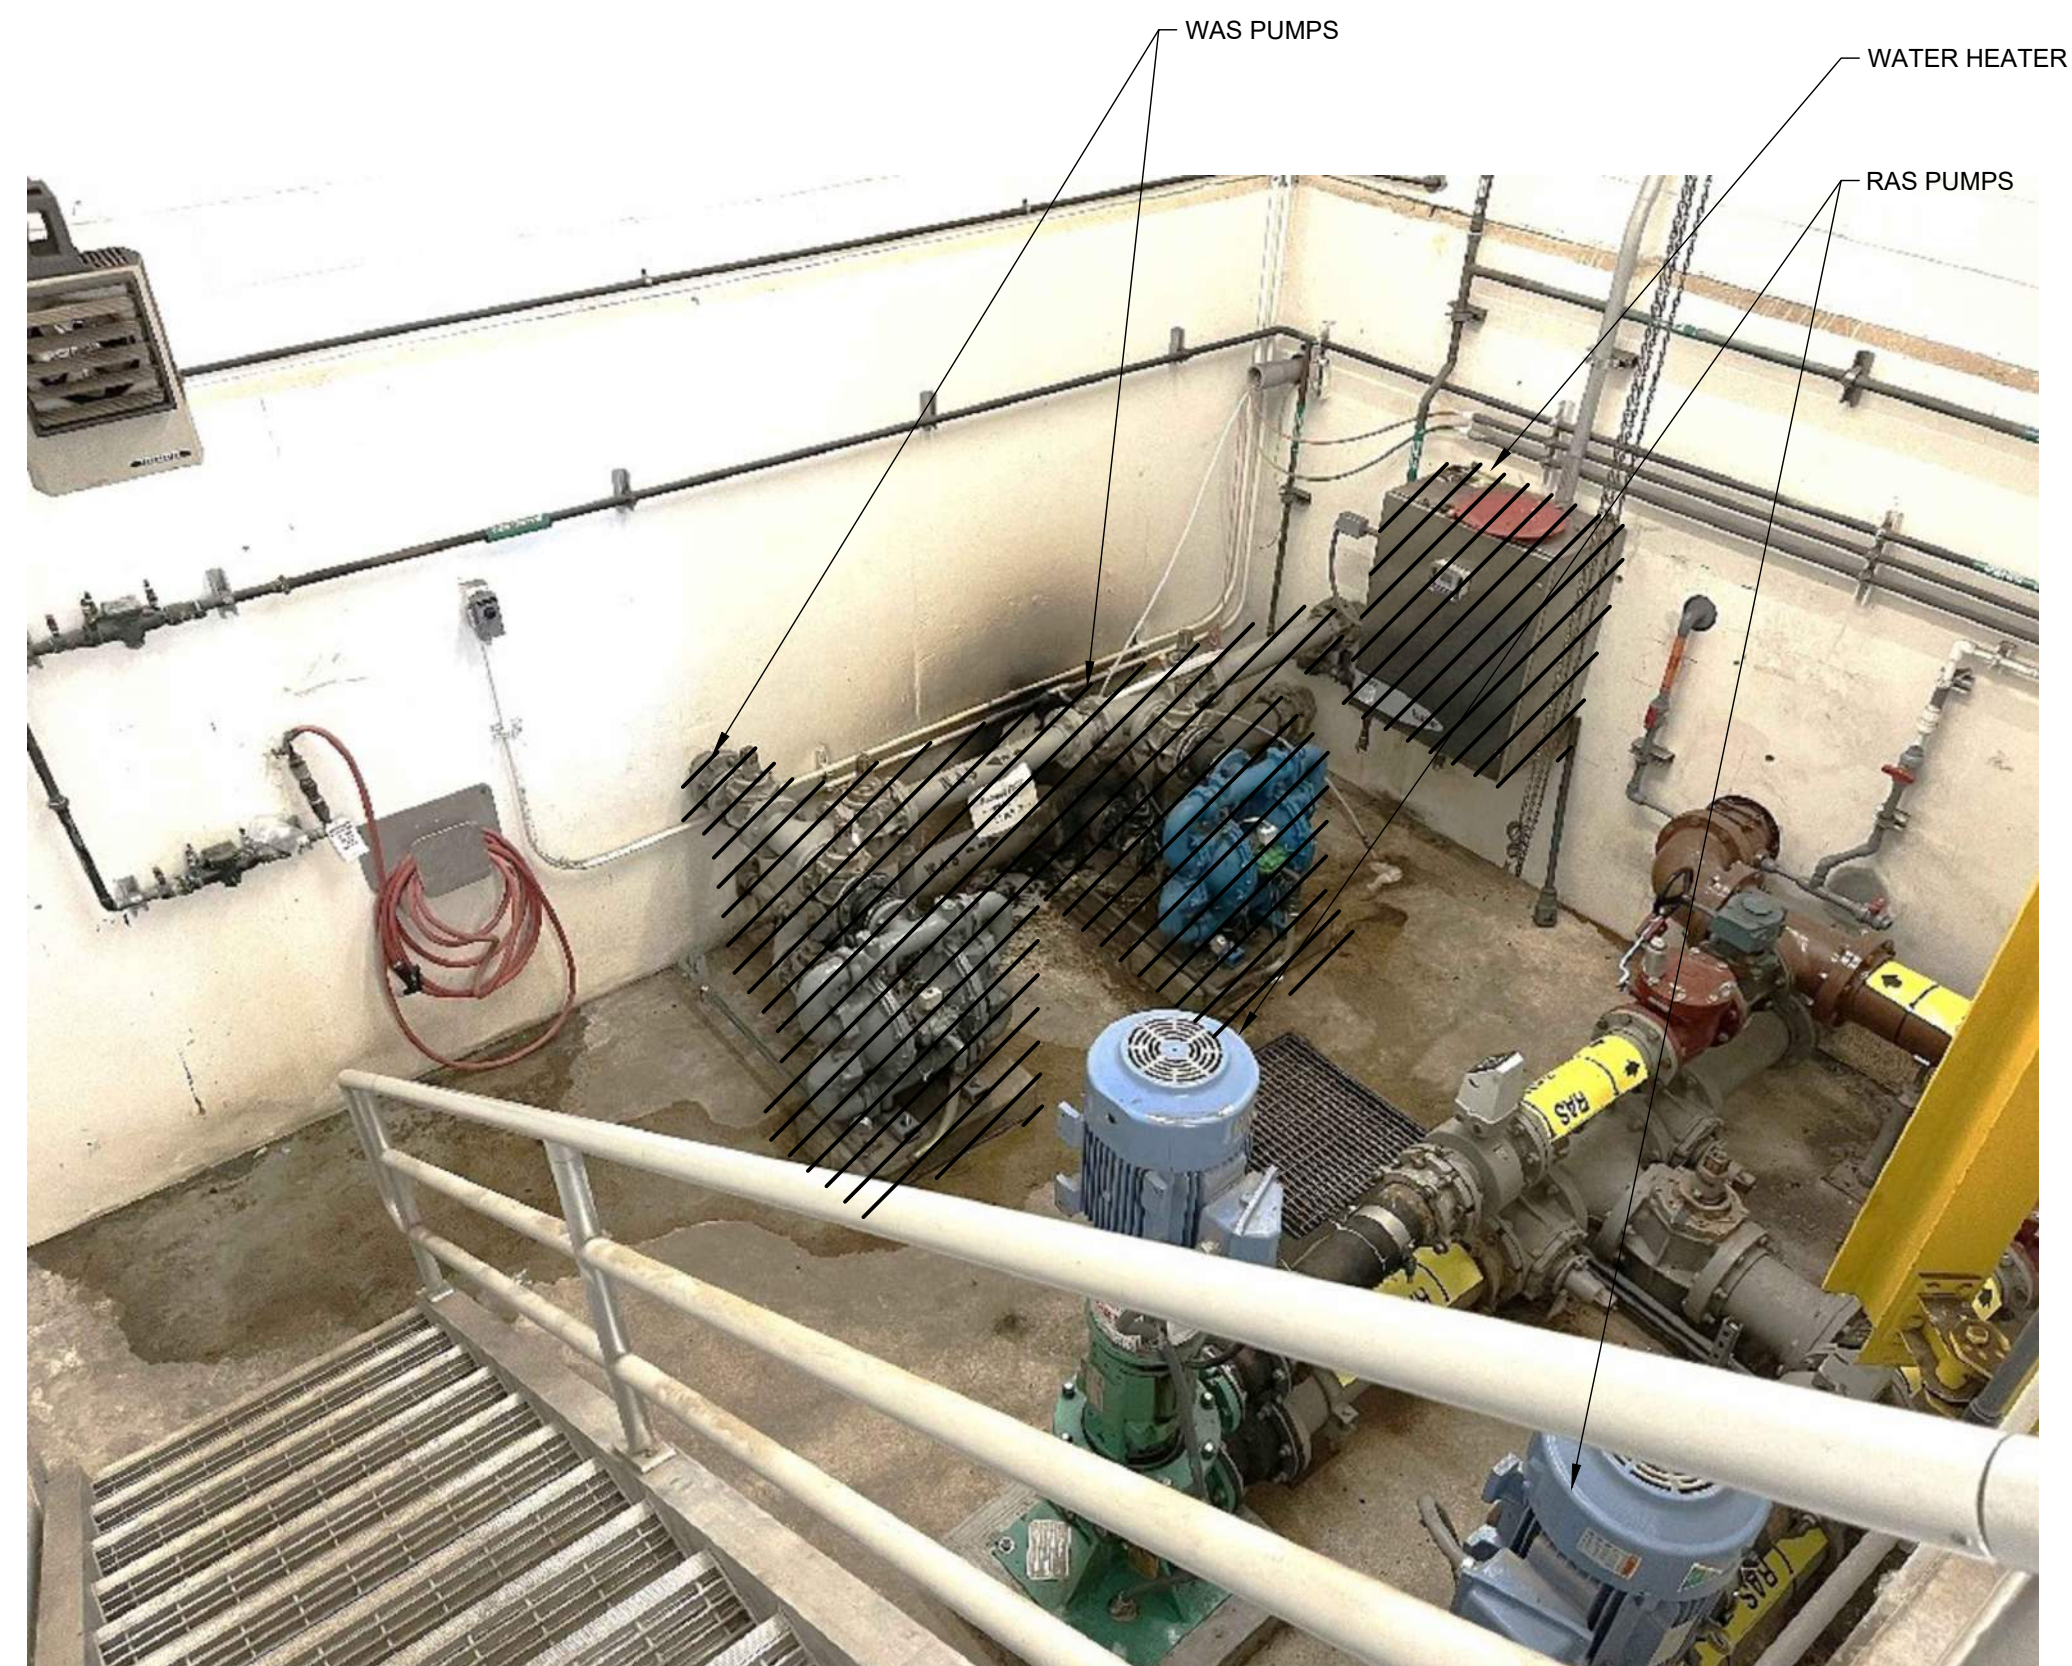



PHOTO - OVERALL DEMOLITION

NO SCALE



PHOTO - PIPING DEMOLITION

NO SCALE

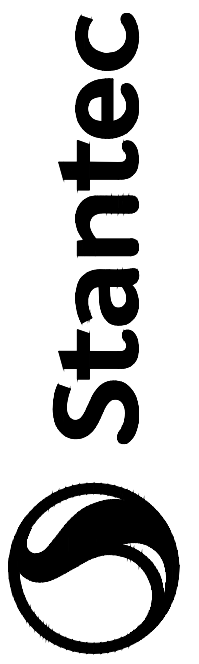

Stantec
601 SW 2nd Ave Suite 1400
Portland, Oregon, 97204
Tel: +1.503.226.7377
www.stantec.com

The Contractor shall verify and be responsible for all dimensions. DO NOT scale the drawing - any errors or omissions shall be reported to Stantec without delay. The Copyrights to all designs and drawings are the property of Stantec. Reproduction or use for any purpose other than that authorized by Stantec is forbidden.

Consultant

[illegible][illegible]

Permit/Seal



EXPIRES: 12-31-26

Client/Project
CITY OF SANDY

WASTE SLUDGE AND SCUM
PUMP REPLACEMENT
PROJECT
Sandy, OR

Project No.: 2002006370

File Name: 06370DD901

Scale: NO SCALE

MT	WS	AO	2025.04.25
Dwn.	Dsgn.	Chkd.	YYYY.MM.DD

Title
WAS PUMP STATION
DEMOLITION PICTURES

Revision: Sheet: of
Drawing No.

DD901



SHEET KEYNOTES

- A. REMOVE EXISTING SCUM PUMP AND HOSE.
- B. DEMOLISH AND REMOVE GRATING AND MANHOLE COVER. CHIP OUT CONCRETE AND ASPHALT DOWN TO SUBGRADE.

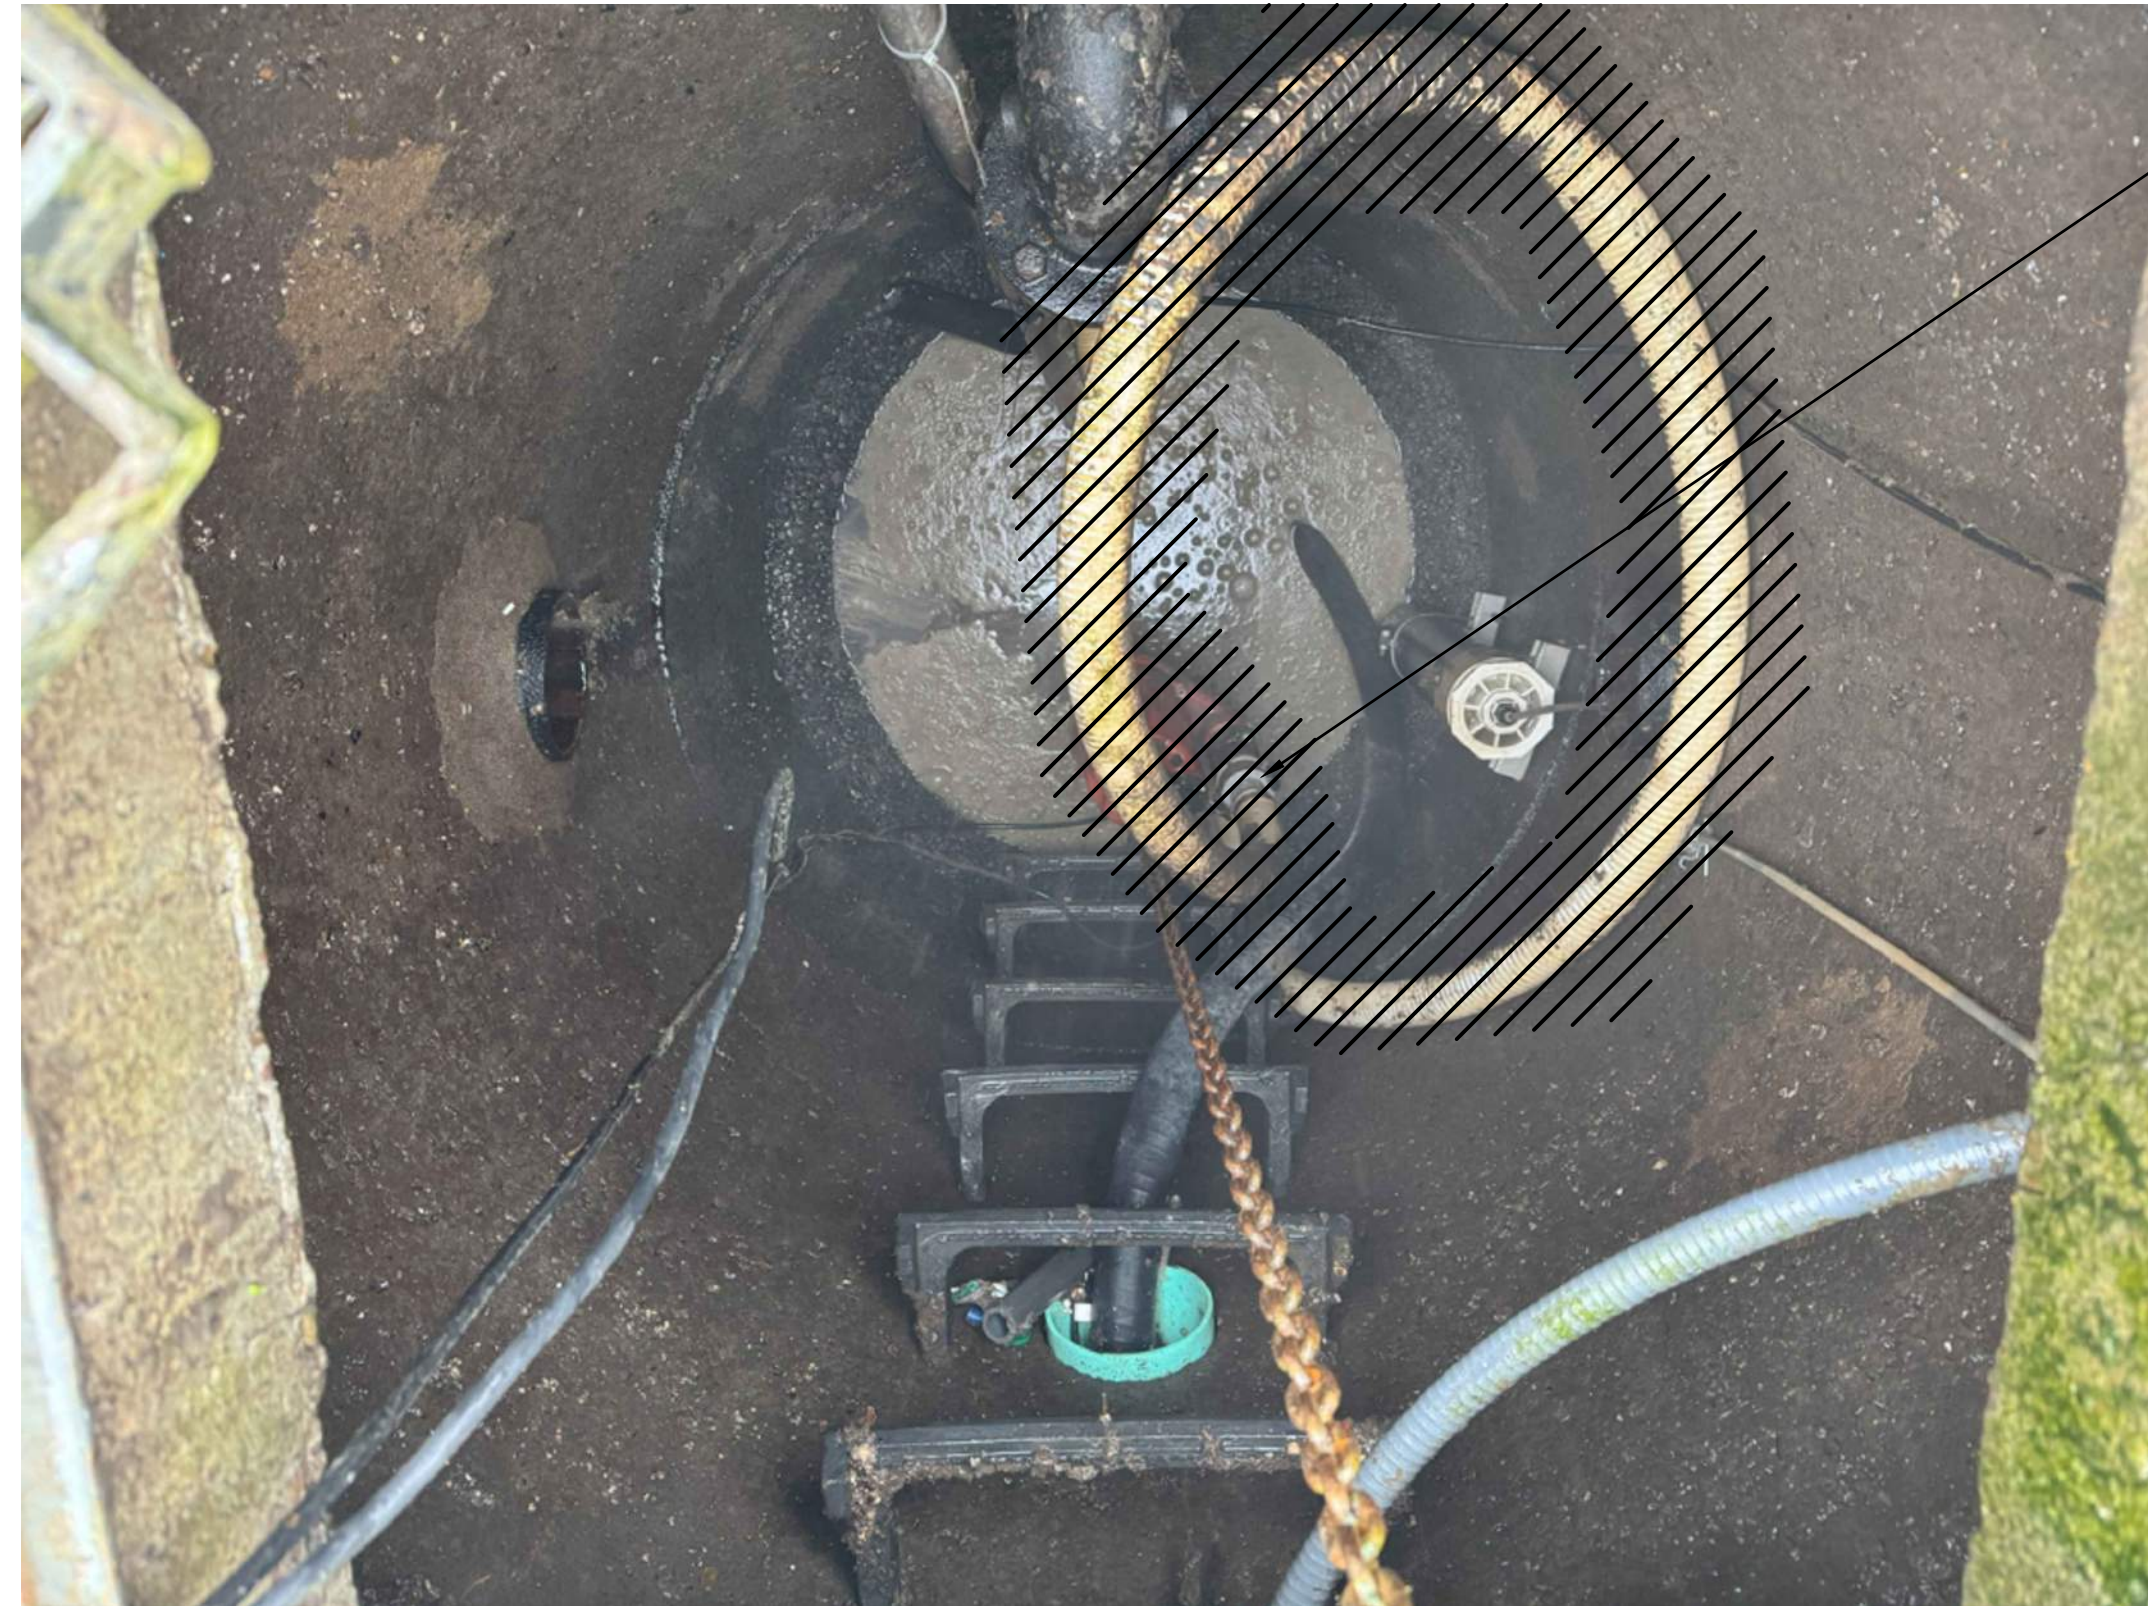


PHOTO - OVERALL DEMOLITION

NO SCALE



PHOTO - SCUM PIT GRATING DEMOLITION

NO SCALE



Stantec
601 SW 2nd Ave Suite 1400
Portland, Oregon, 97204
Tel: +1.503.226.7377
www.stantec.com

The Contractor shall verify and be responsible for all dimensions. DO NOT scale the drawing—any errors or omissions shall be reported to Stantec without delay. The Copyrights to all designs and drawings are the property of Stantec. Reproduction or use for any purpose other than that authorized by Stantec is forbidden.

Consultant

[illegible][illegible]

Permit/Seal



Client/Project
CITY OF SANDY

WASTE SLUDGE AND SCUM
PUMP REPLACEMENT
PROJECT
Sandy, OR

Project No.: 2002006370

File Name: 06370DD902

Scale: NO SCALE

MT	WS	AO	2025.04.25
Dwn.	Dsgn.	Chkd.	YYYY.MM.DD

Title





SCUM PUMP STATION
DEMOLITION PICTURE

Revision:	Sheet:	of
Drawing No.		

DD902

GENERAL SHEET NOTES

1. PREFERRED WAS PUMP: BOERGER MODEL PL 200 (RIGHT ANGLE CONFIGURATION) OR EQUAL.

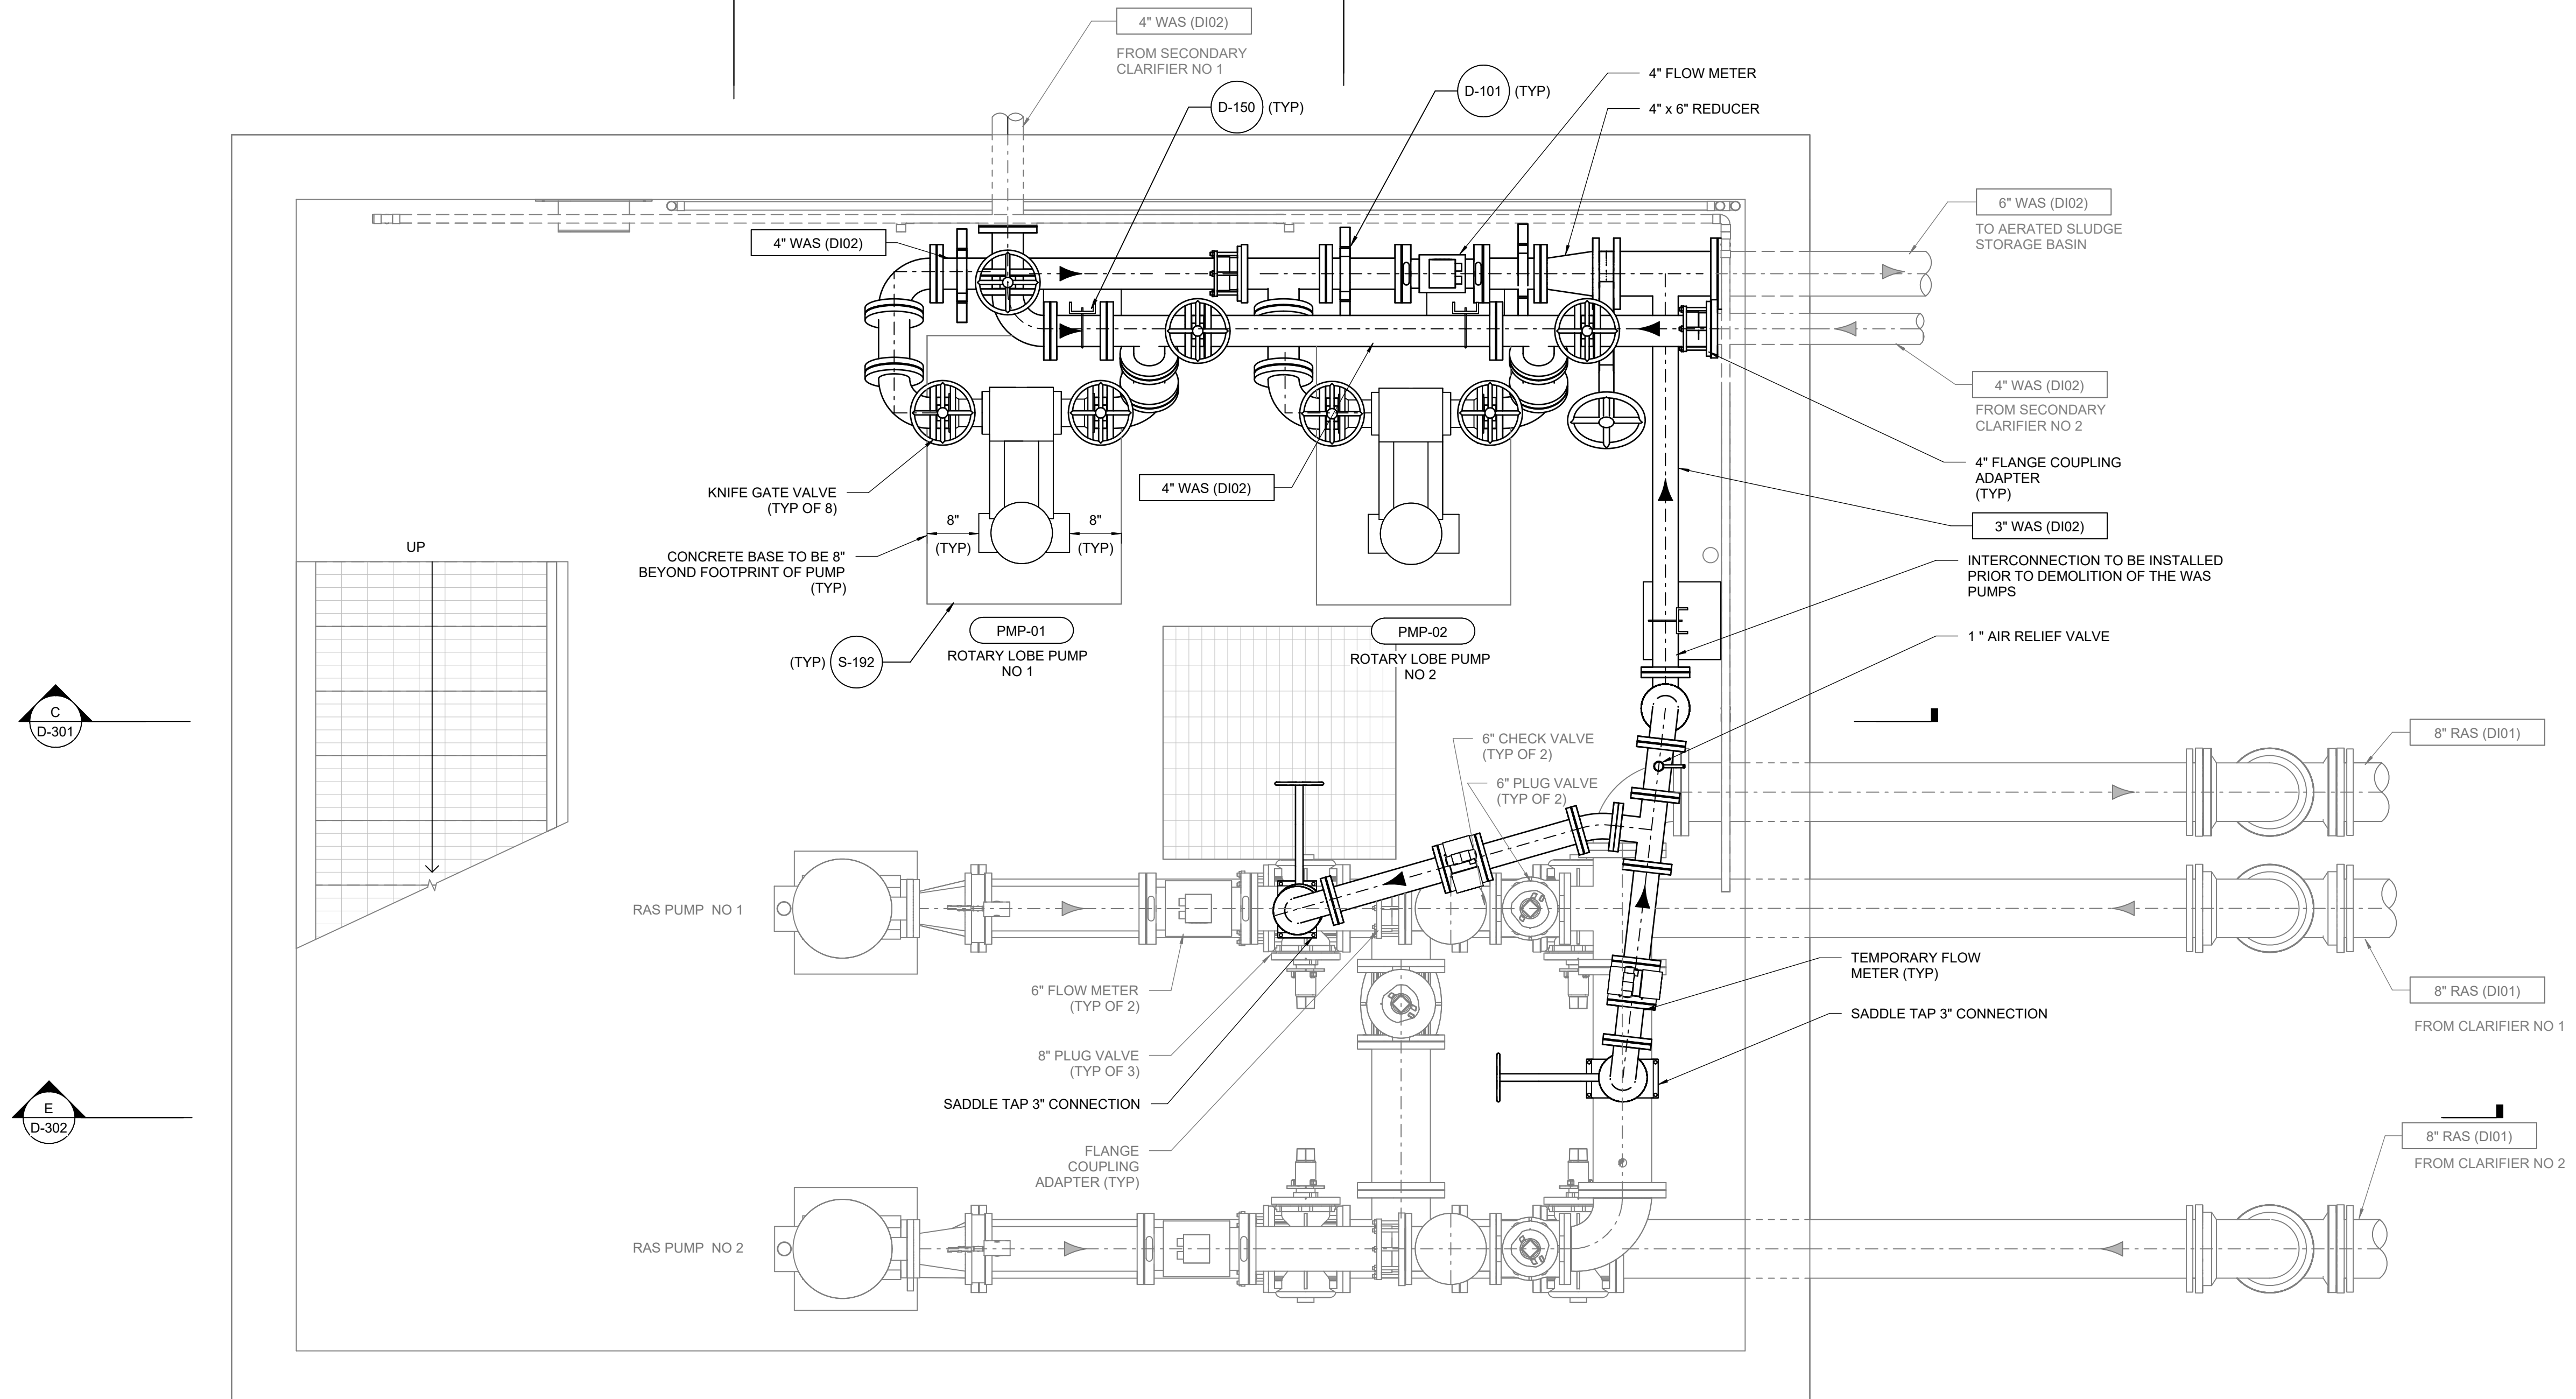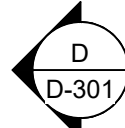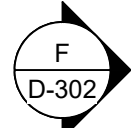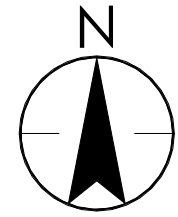

601 SW 2nd Ave Suite 1400
Portland, Oregon, 97204
Tel: +1 503.226.7377
www.stantec.com

Discussion

[illegible][illegible]

Permit/Seal



City of Sandy
Waste Sludge and Scum
Pump Replacement
Project
Sandy, OR

Project No.:2002006370

e Name: 06370d-md.rvt

scale: $3/4" = 1'-0"$


<u>AL</u>	<u>SW</u>	<u>AO</u>	<u>2025.04.25</u>
Dwn.	Dsgn.	Chkd.	YYYY.MM.DD

UMP STATION
LANS

Revision: _____

Drawing No. _____

D-101

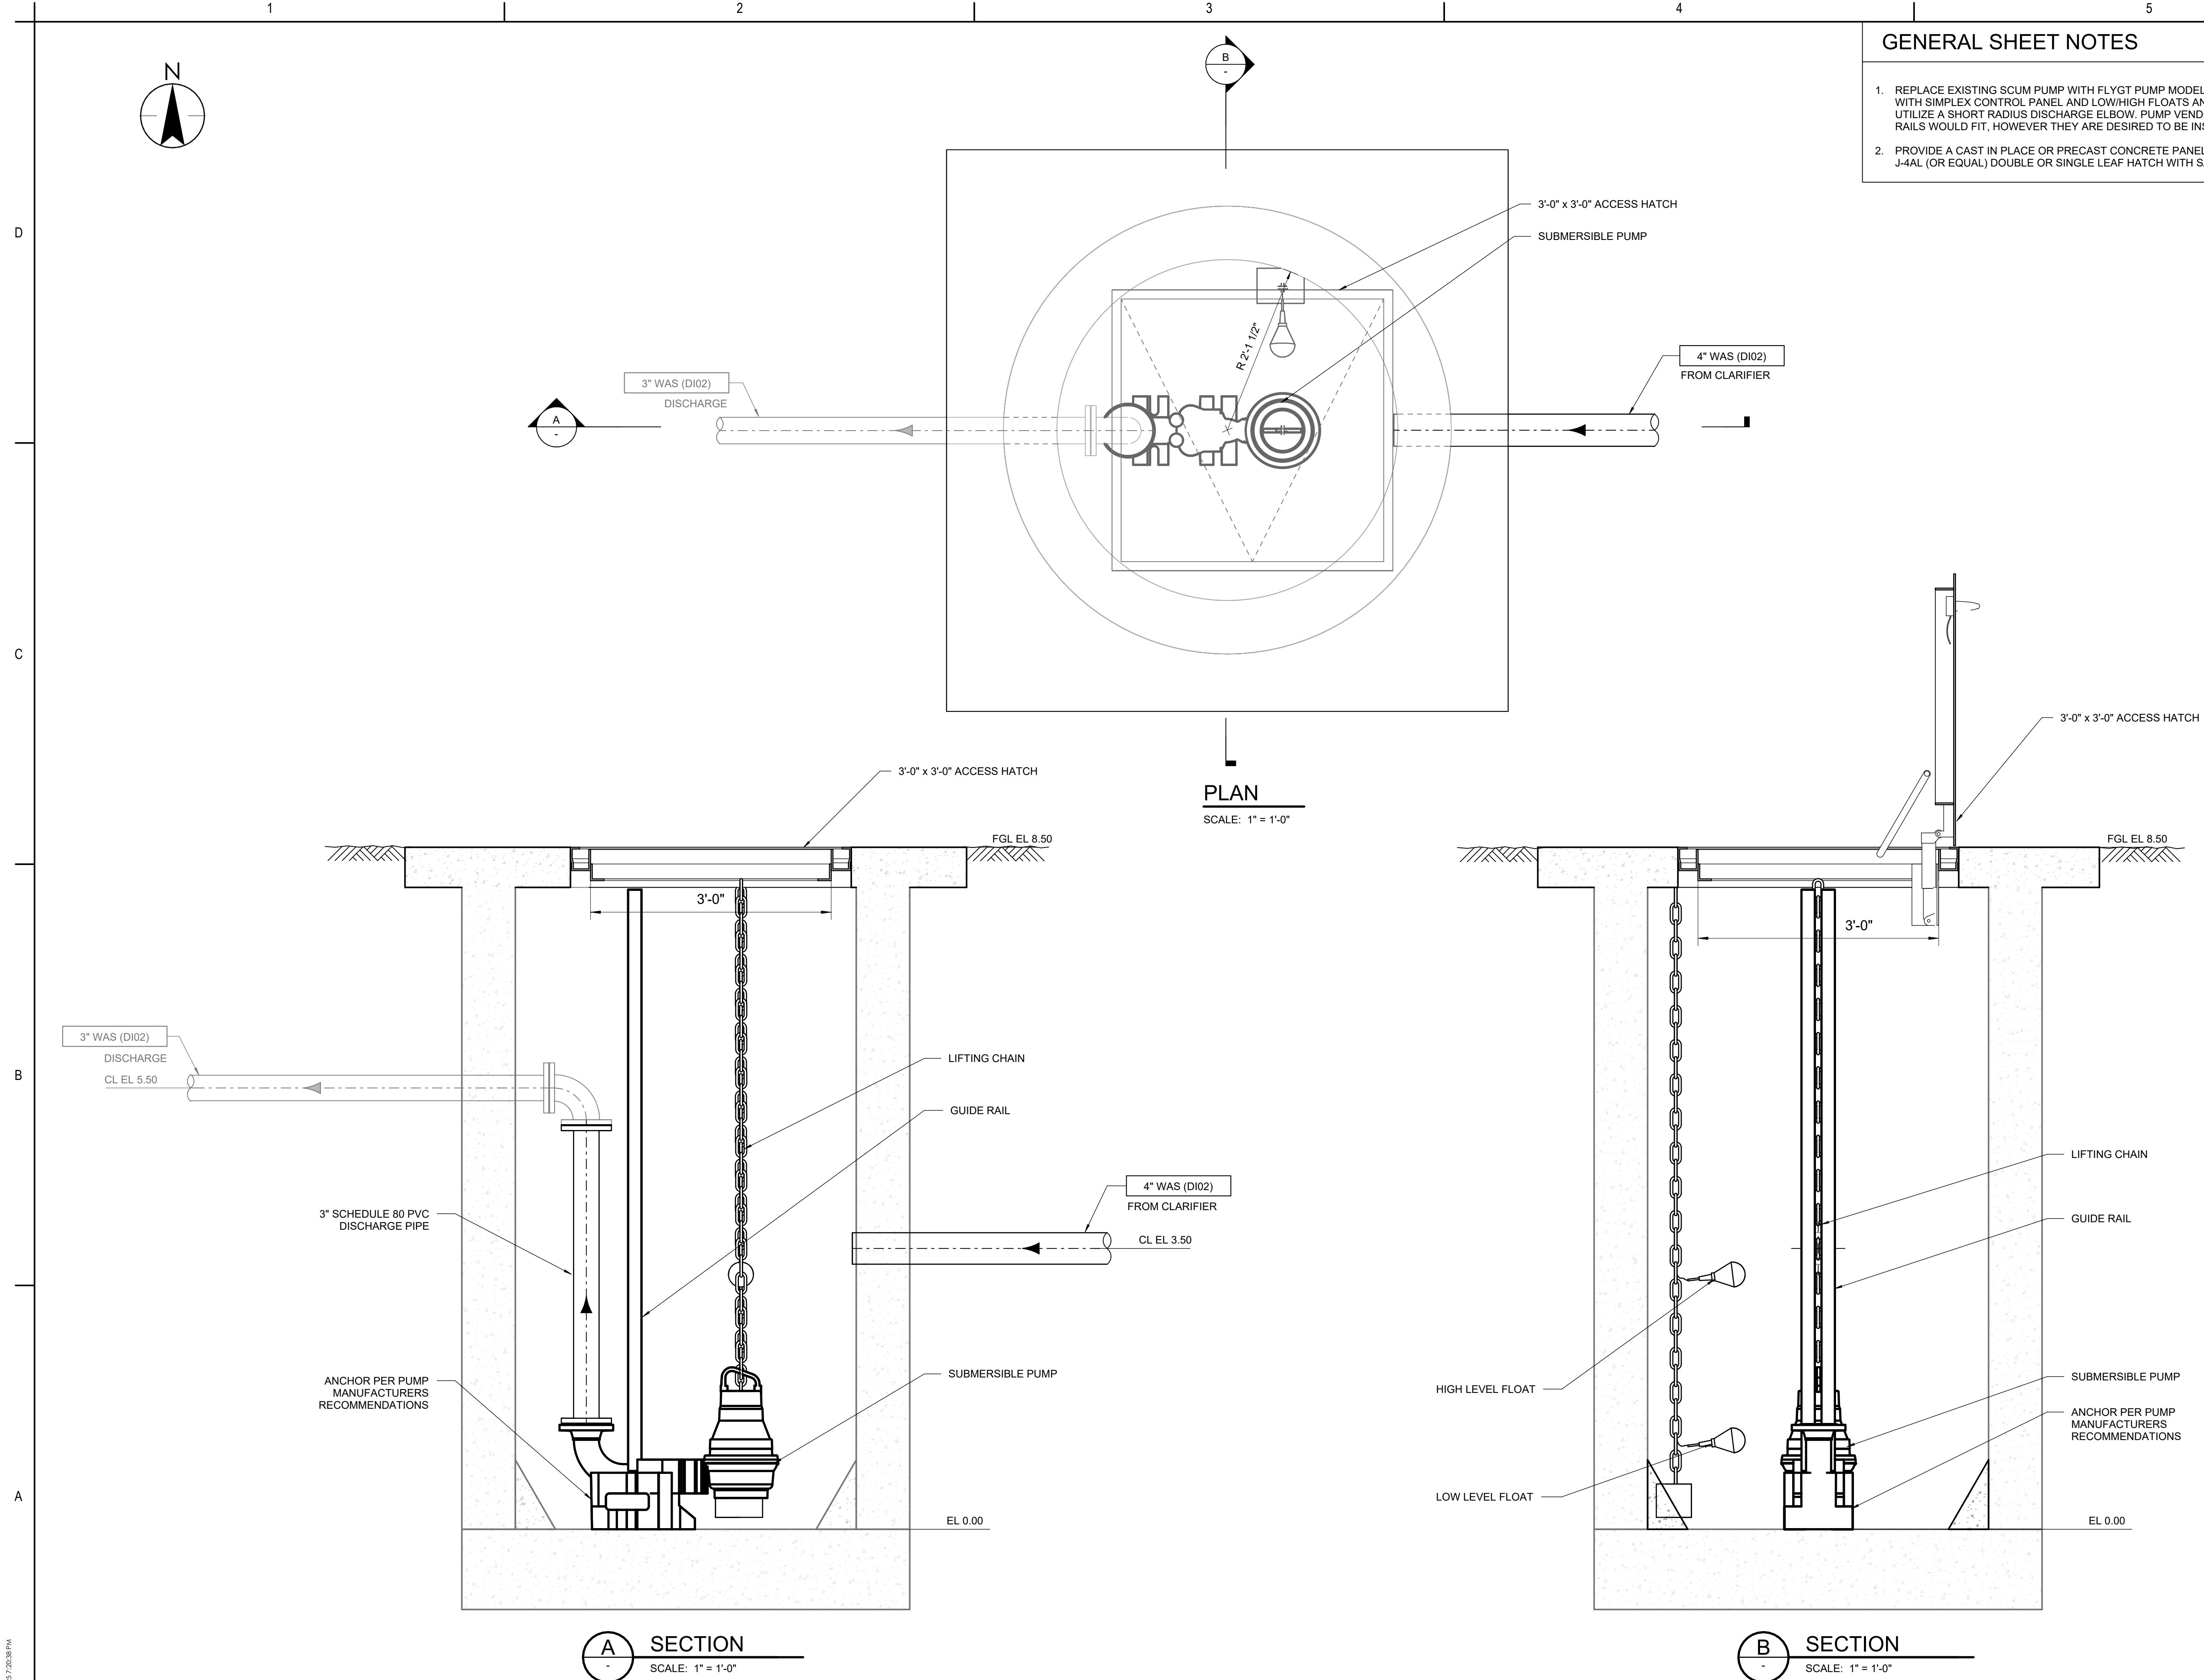

- ## GENERAL SHEET NOTES



Consultant

[illegible]

Client/Project
CITY OF SANDY

WASTE SLUDGE AND SCUM
PUMP REPLACEMENT
PROJECT

Sandy, OR

File Name: 06380d-md.rvt

Scale: 1" = 1'-0"

RR	SW	AO	2025.04.25
Dwn.	Dsgn.	Chkd.	YYYY.MM.DD



Title
SCUM PUMP STATION
PLAN AND SECTION

Revision: _____
Drawing No. _____

D-102

GENERAL SHEET NOTES

1. PREFERRED WAS PUMP: BOERGER MODEL PL 200 (RIGHT ANGLE CONFIGURATION) OR EQUAL.
2. PADDLEWHEEL FLOW METER SHALL BE ICON TRUFLO TKB SERIES (BATTERY POWERED) PADDLEWHEEL FLOW METER.

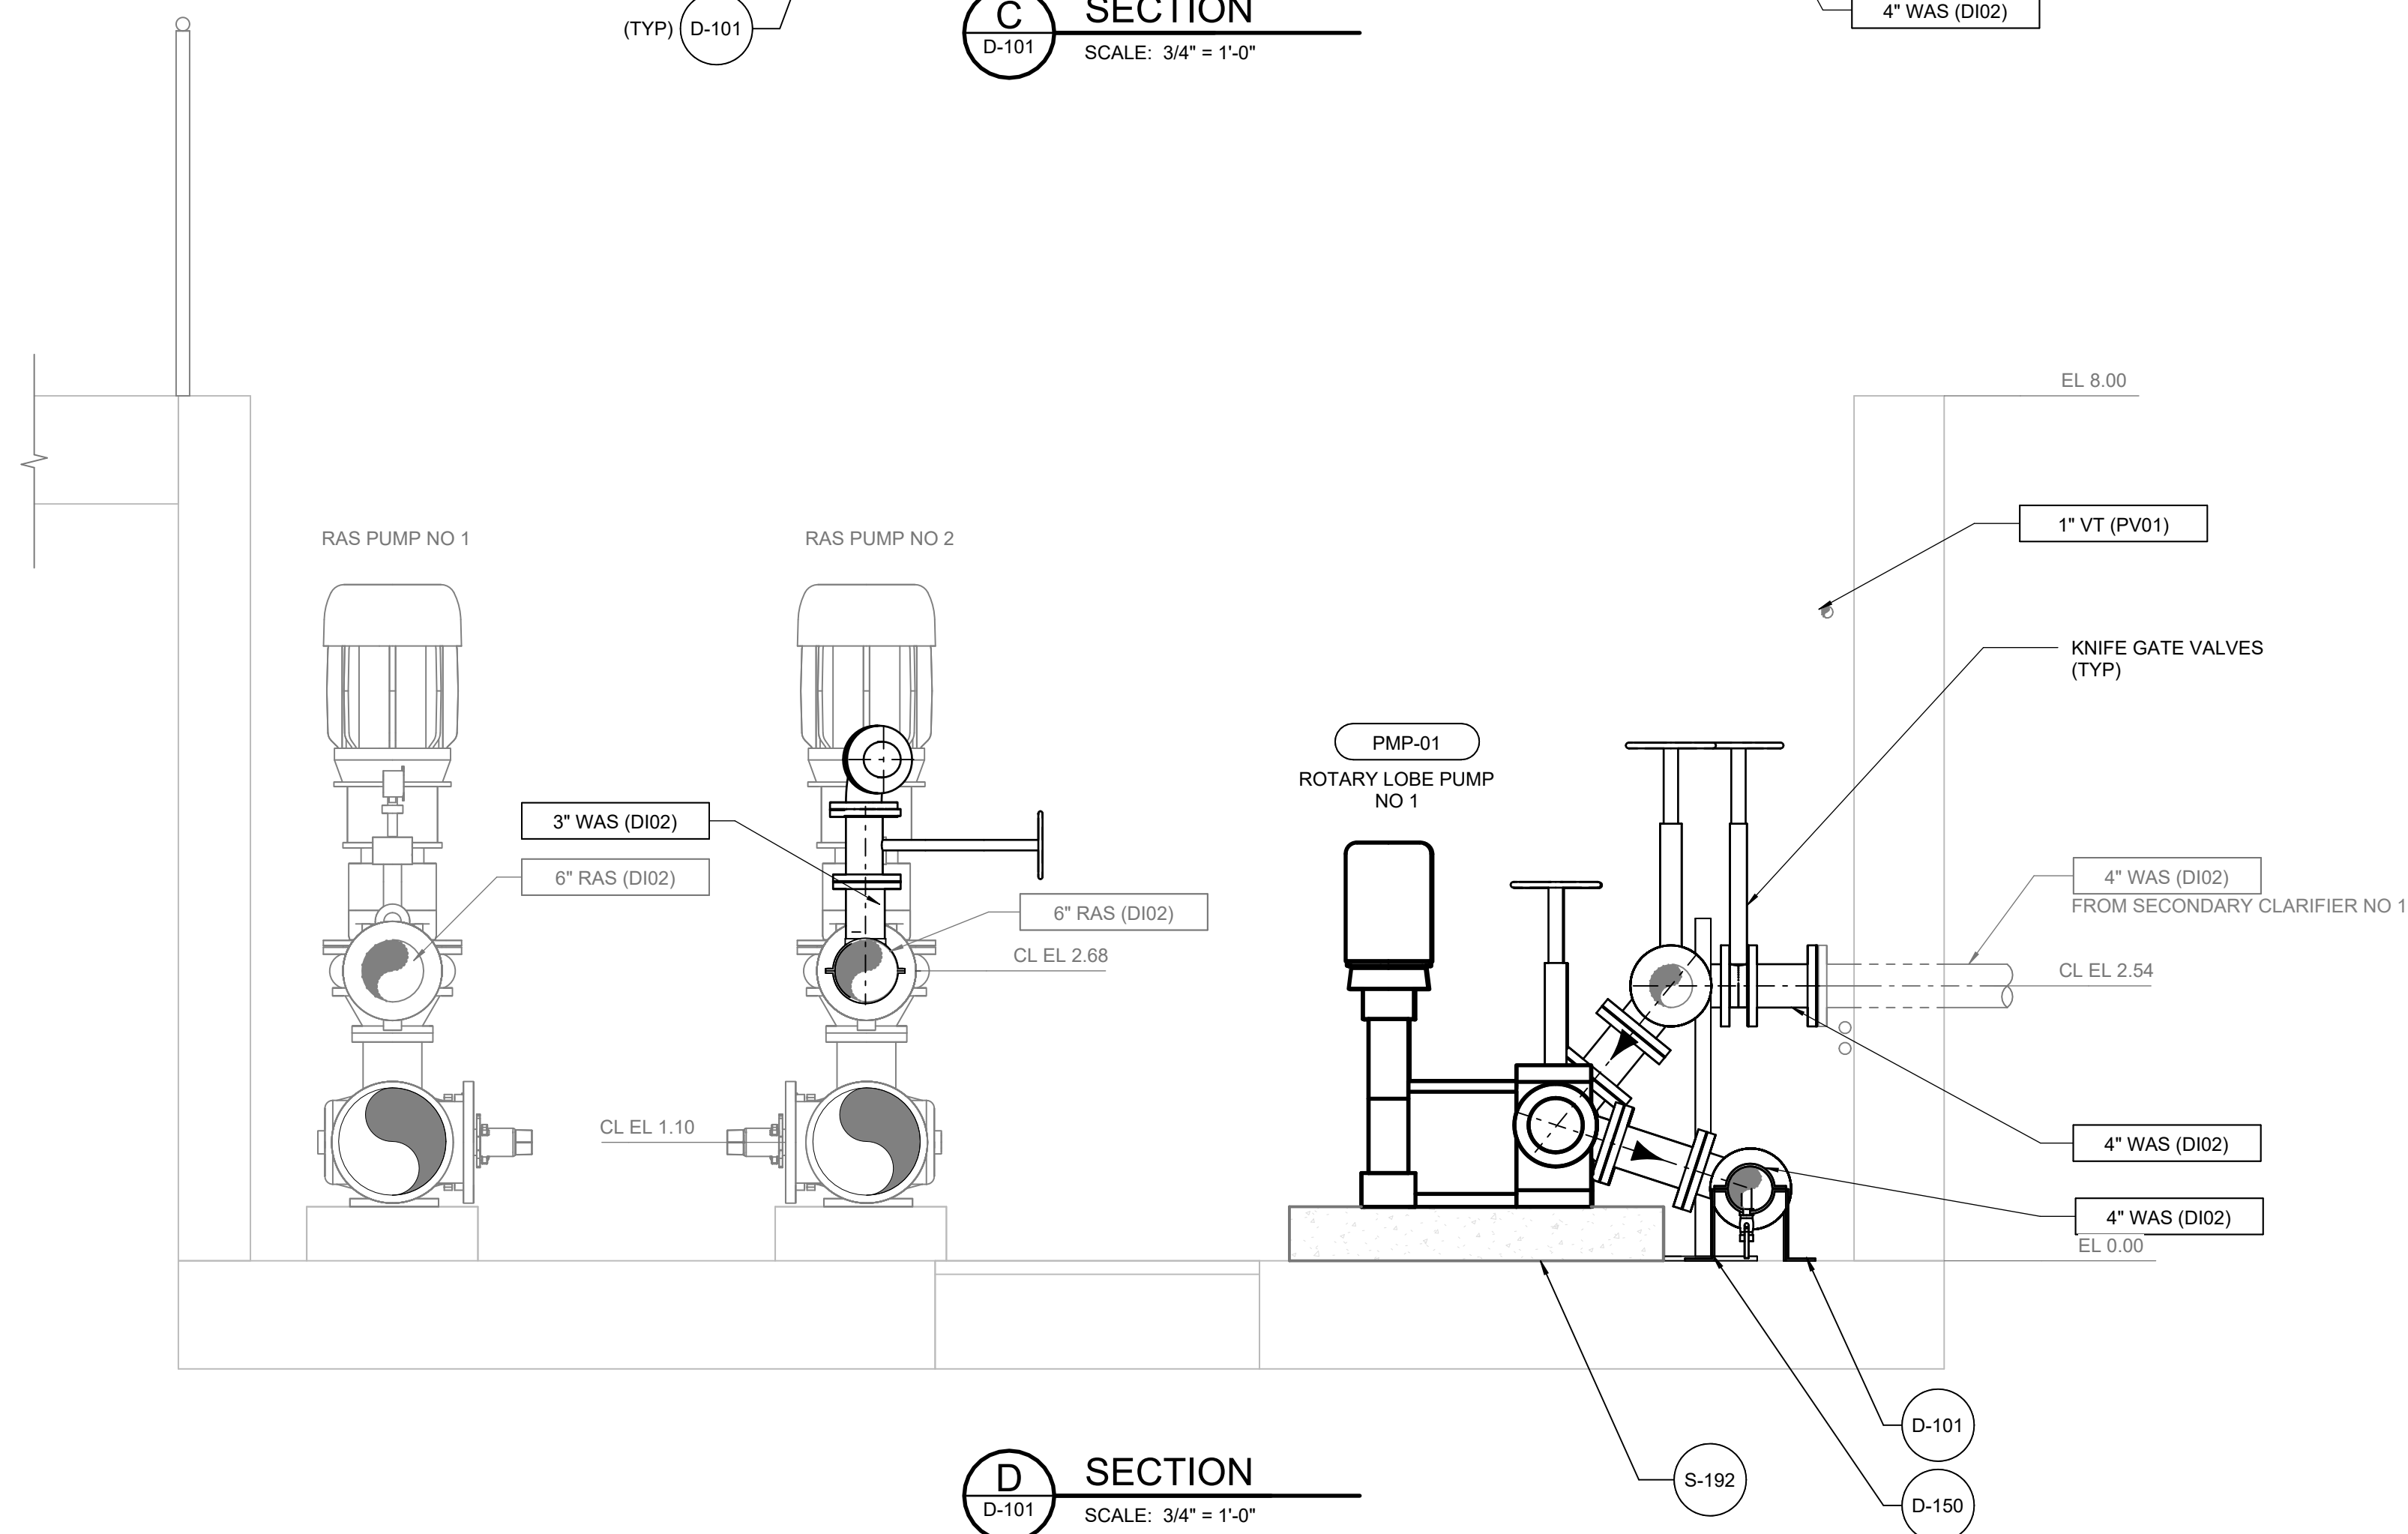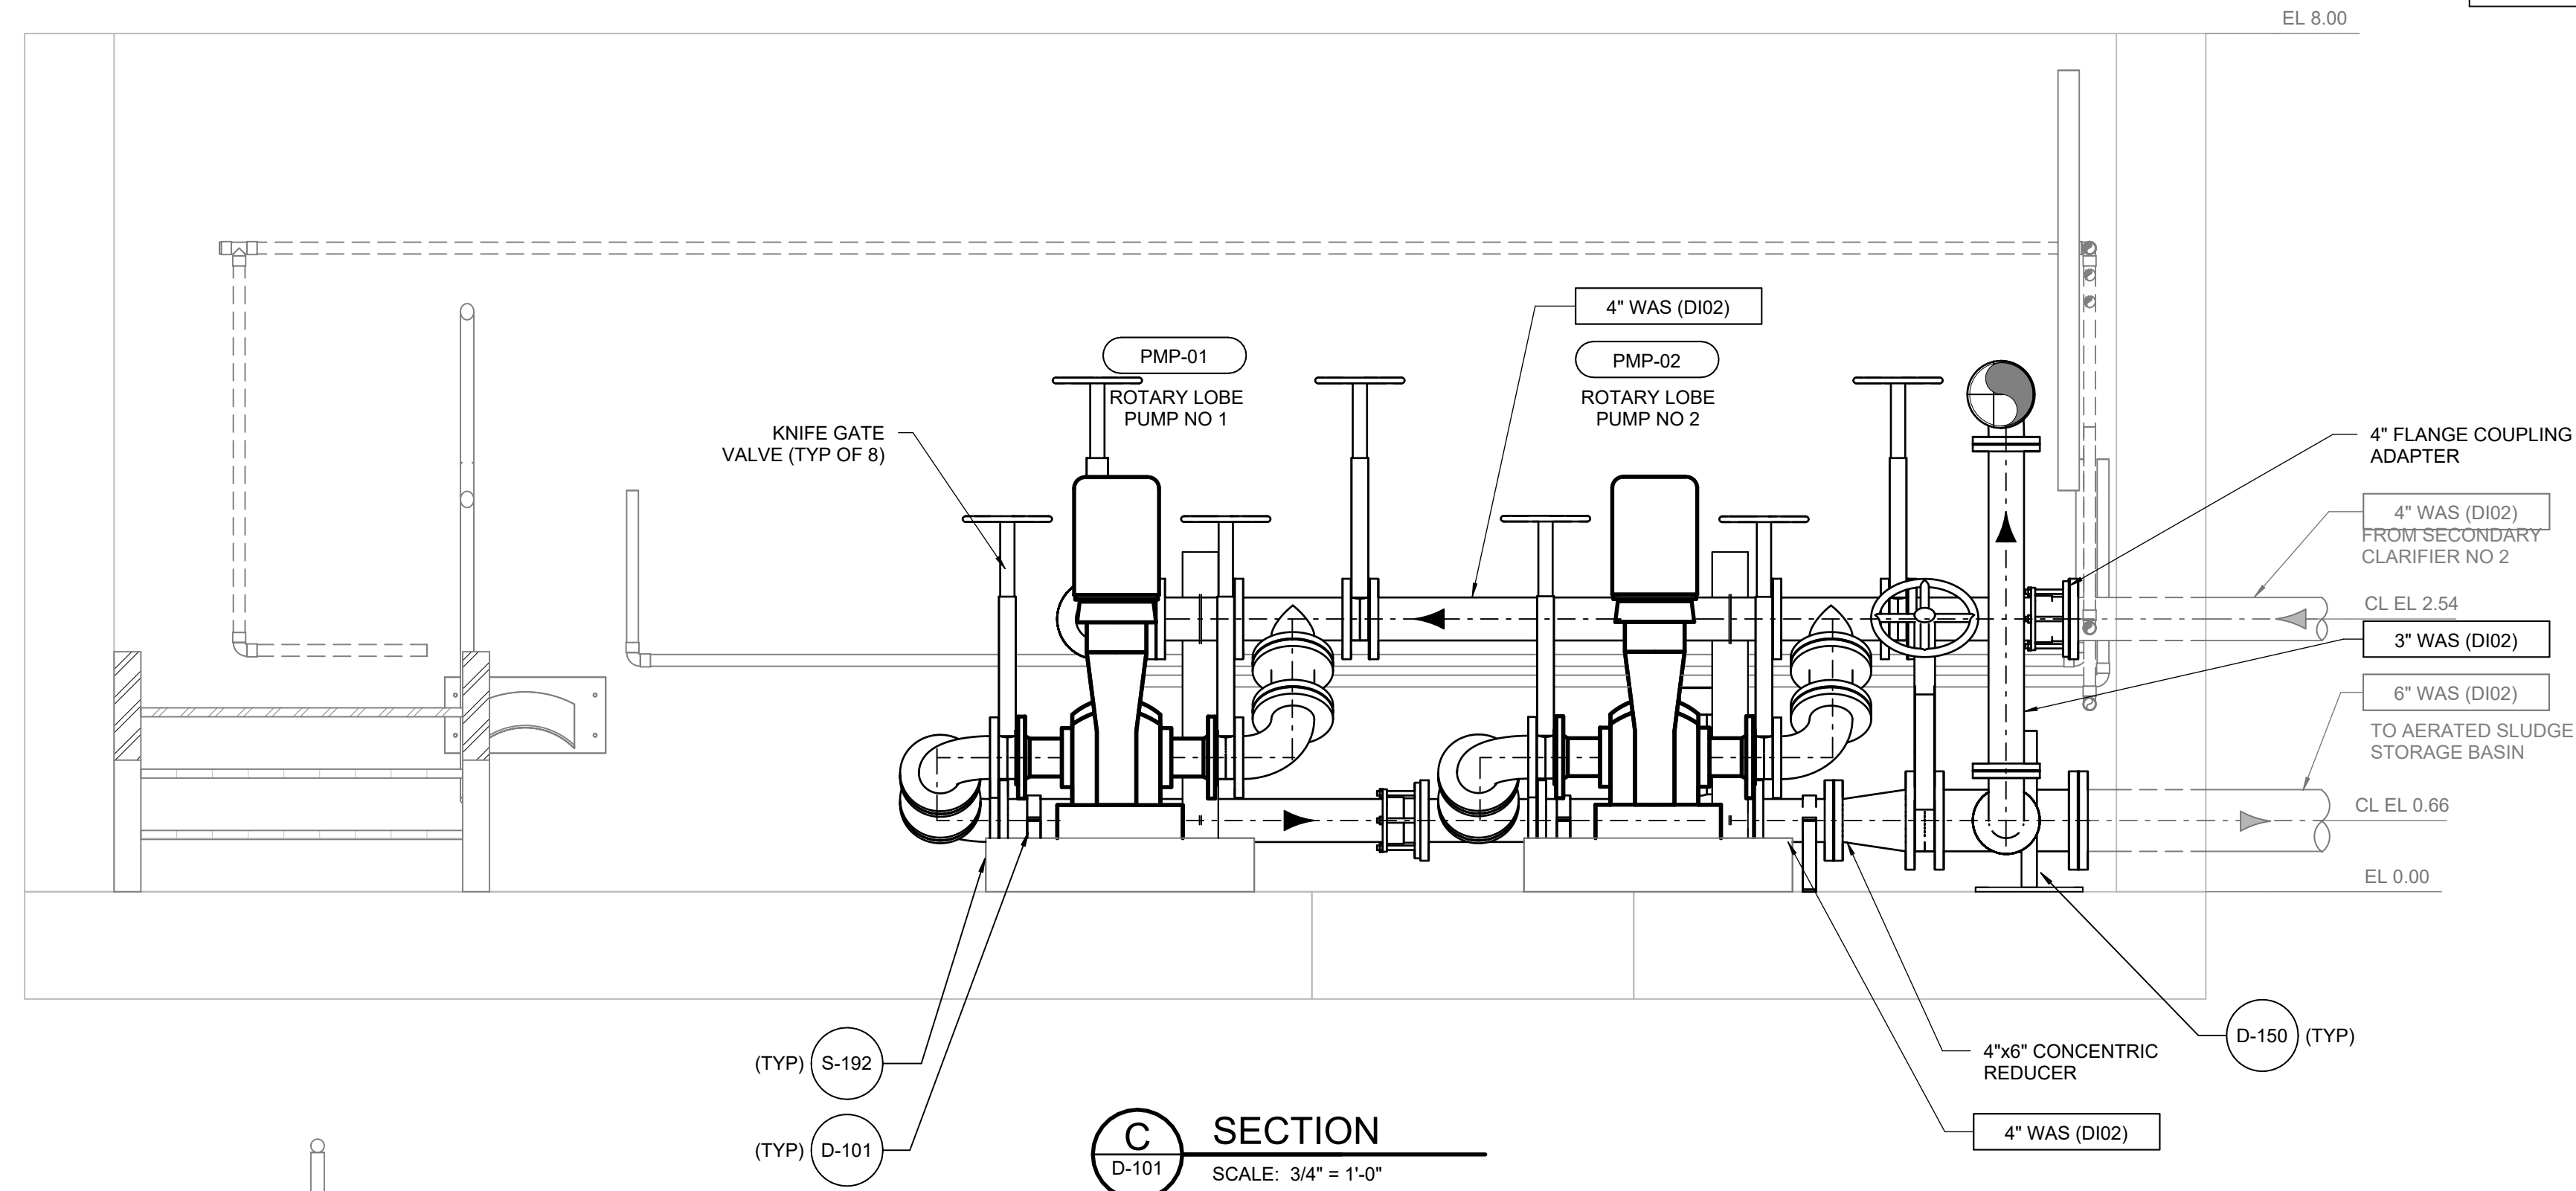

Stantec
601 SW 2nd Ave Suite 1400
Portland, Oregon, 97204
Tel: +1.503.226.7377
www.stantec.com

The Contractor shall verify and be responsible for all dimensions. DO NOT scale the drawing - any errors or omissions shall be reported to Stantec without delay.
The Copyrights to all designs and drawings are the property of Stantec. Reproduction is prohibited.

Consultant

[illegible]

Permit/Seal



Client/Project
CITY OF SANDY
WASTE SLUDGE AND SCUM
PUMP REPLACEMENT
PROJECT
Sandy, OR

Project No.:2002006370
 File Name: 06370d-md.rvt
 Scale: 3/4" = 1'-0"

AL	SW	AO	2025.04.25
Dwn.	Dsgn.	Chkd.	YYYY.MM.DD

Title
PUMP STATION
SECTIONS - I


Revision: _____
Drawing No. _____

D-301


1
2
3
4
5
D
C
B
A
5/2/2025 7:45:04 PM
ORIGINAL SHEET - ANSI D

GENERAL SHEET NOTES


- PREFERRED WAS PUMP: BOERGER MODEL PL 200 (RIGHT ANGLE CONFIGURATION) OR EQUAL.
- PADDLEWHEEL FLOW METER SHALL BE ICON TRUFLO TKB SERIES (BATTERY POWERED) PADDLEWHEEL FLOW METER.

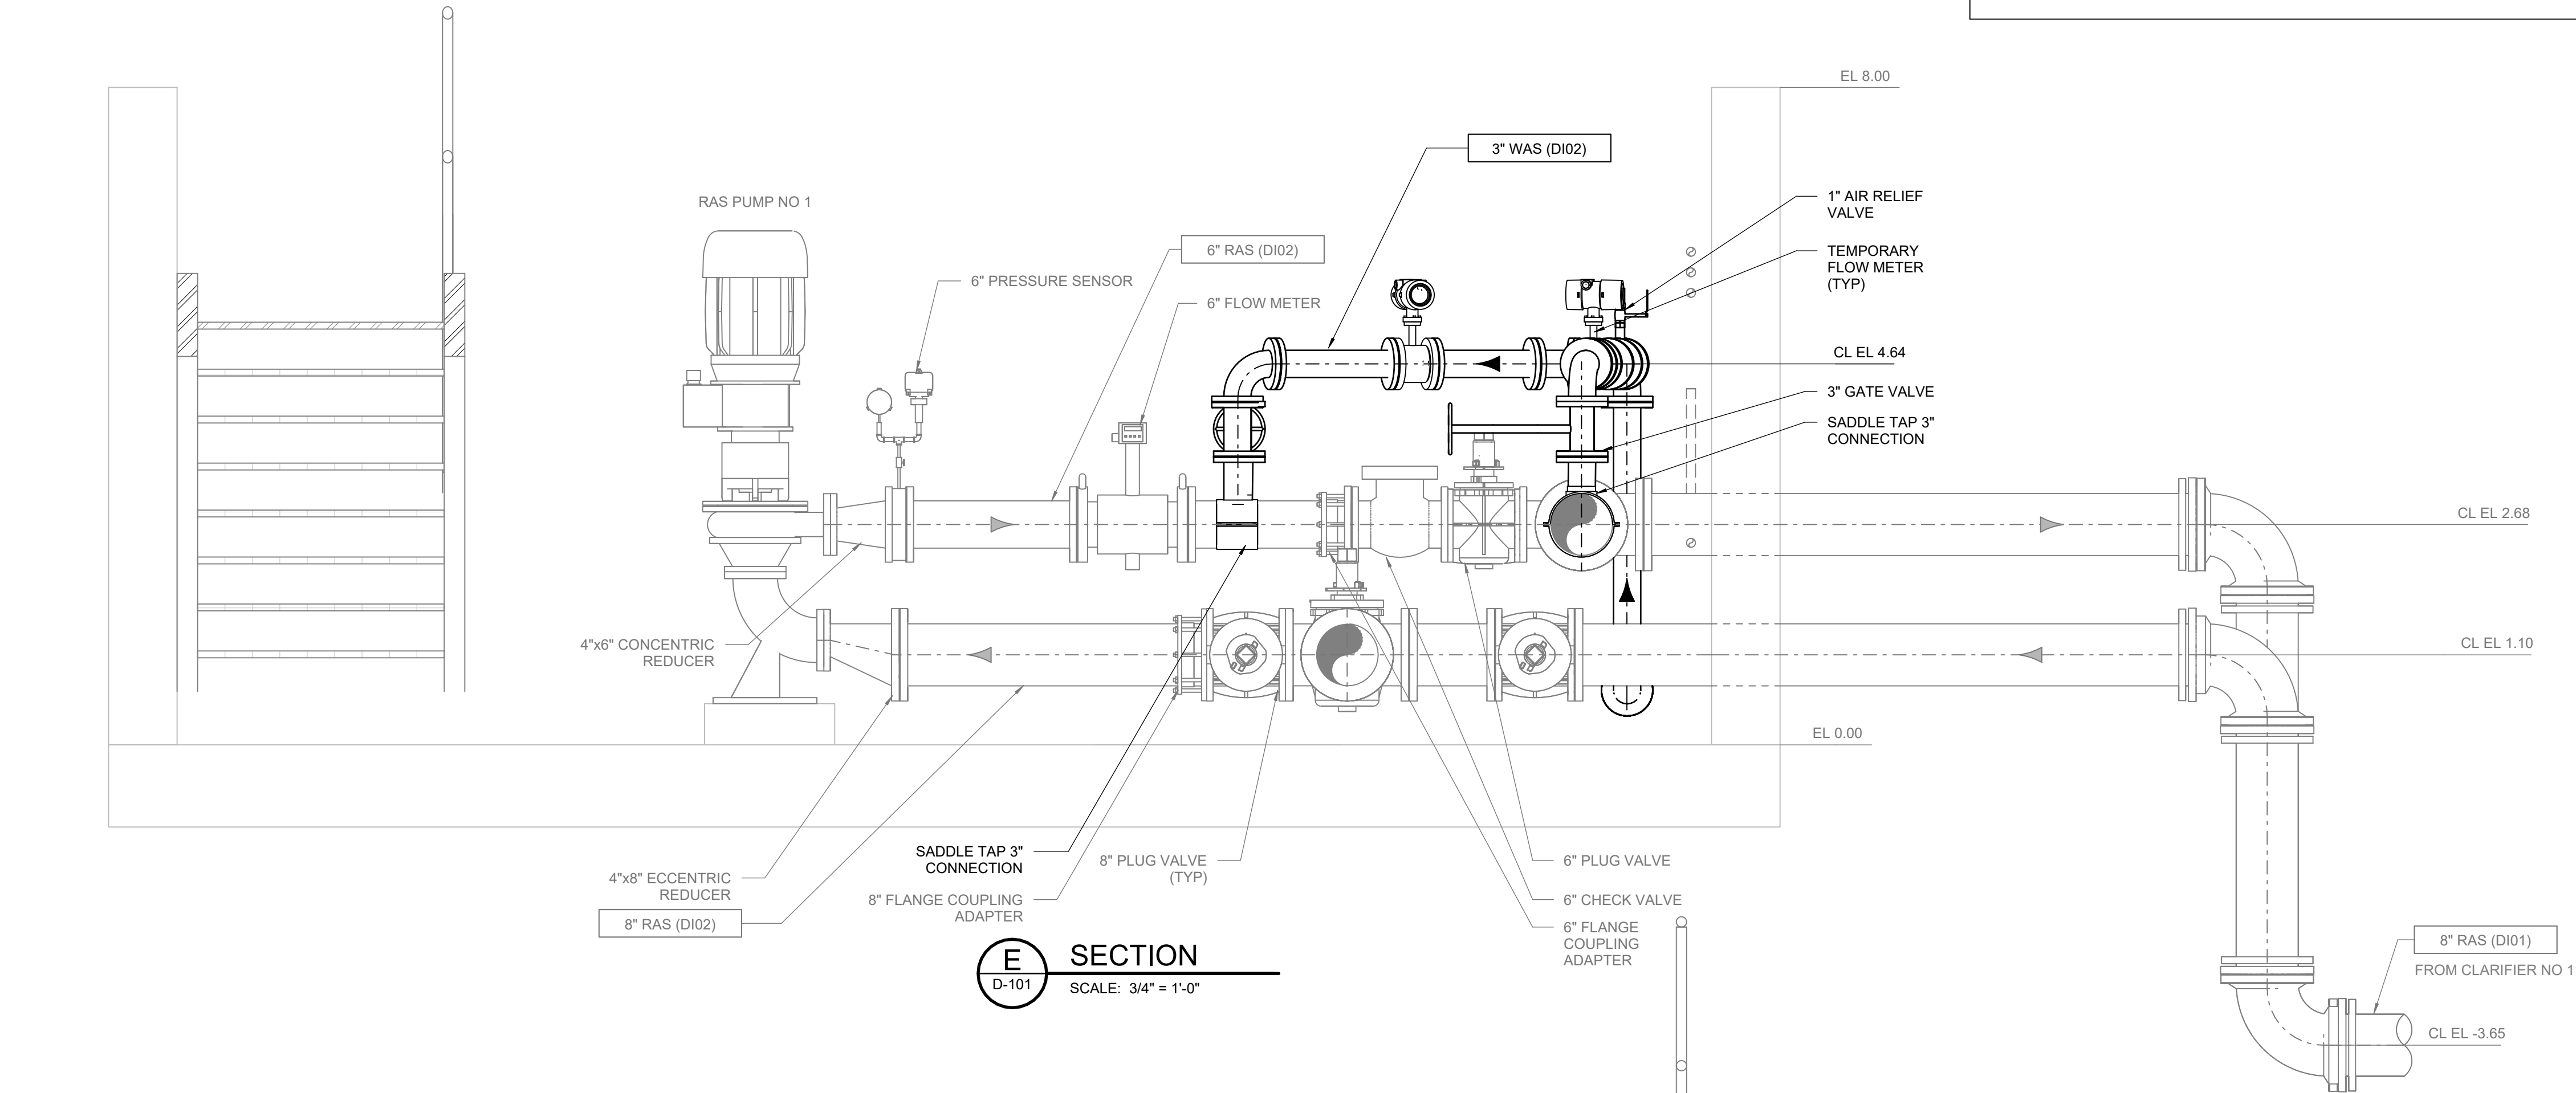

E SECTION
D-101 SCALE: 3/4" = 1'-0"

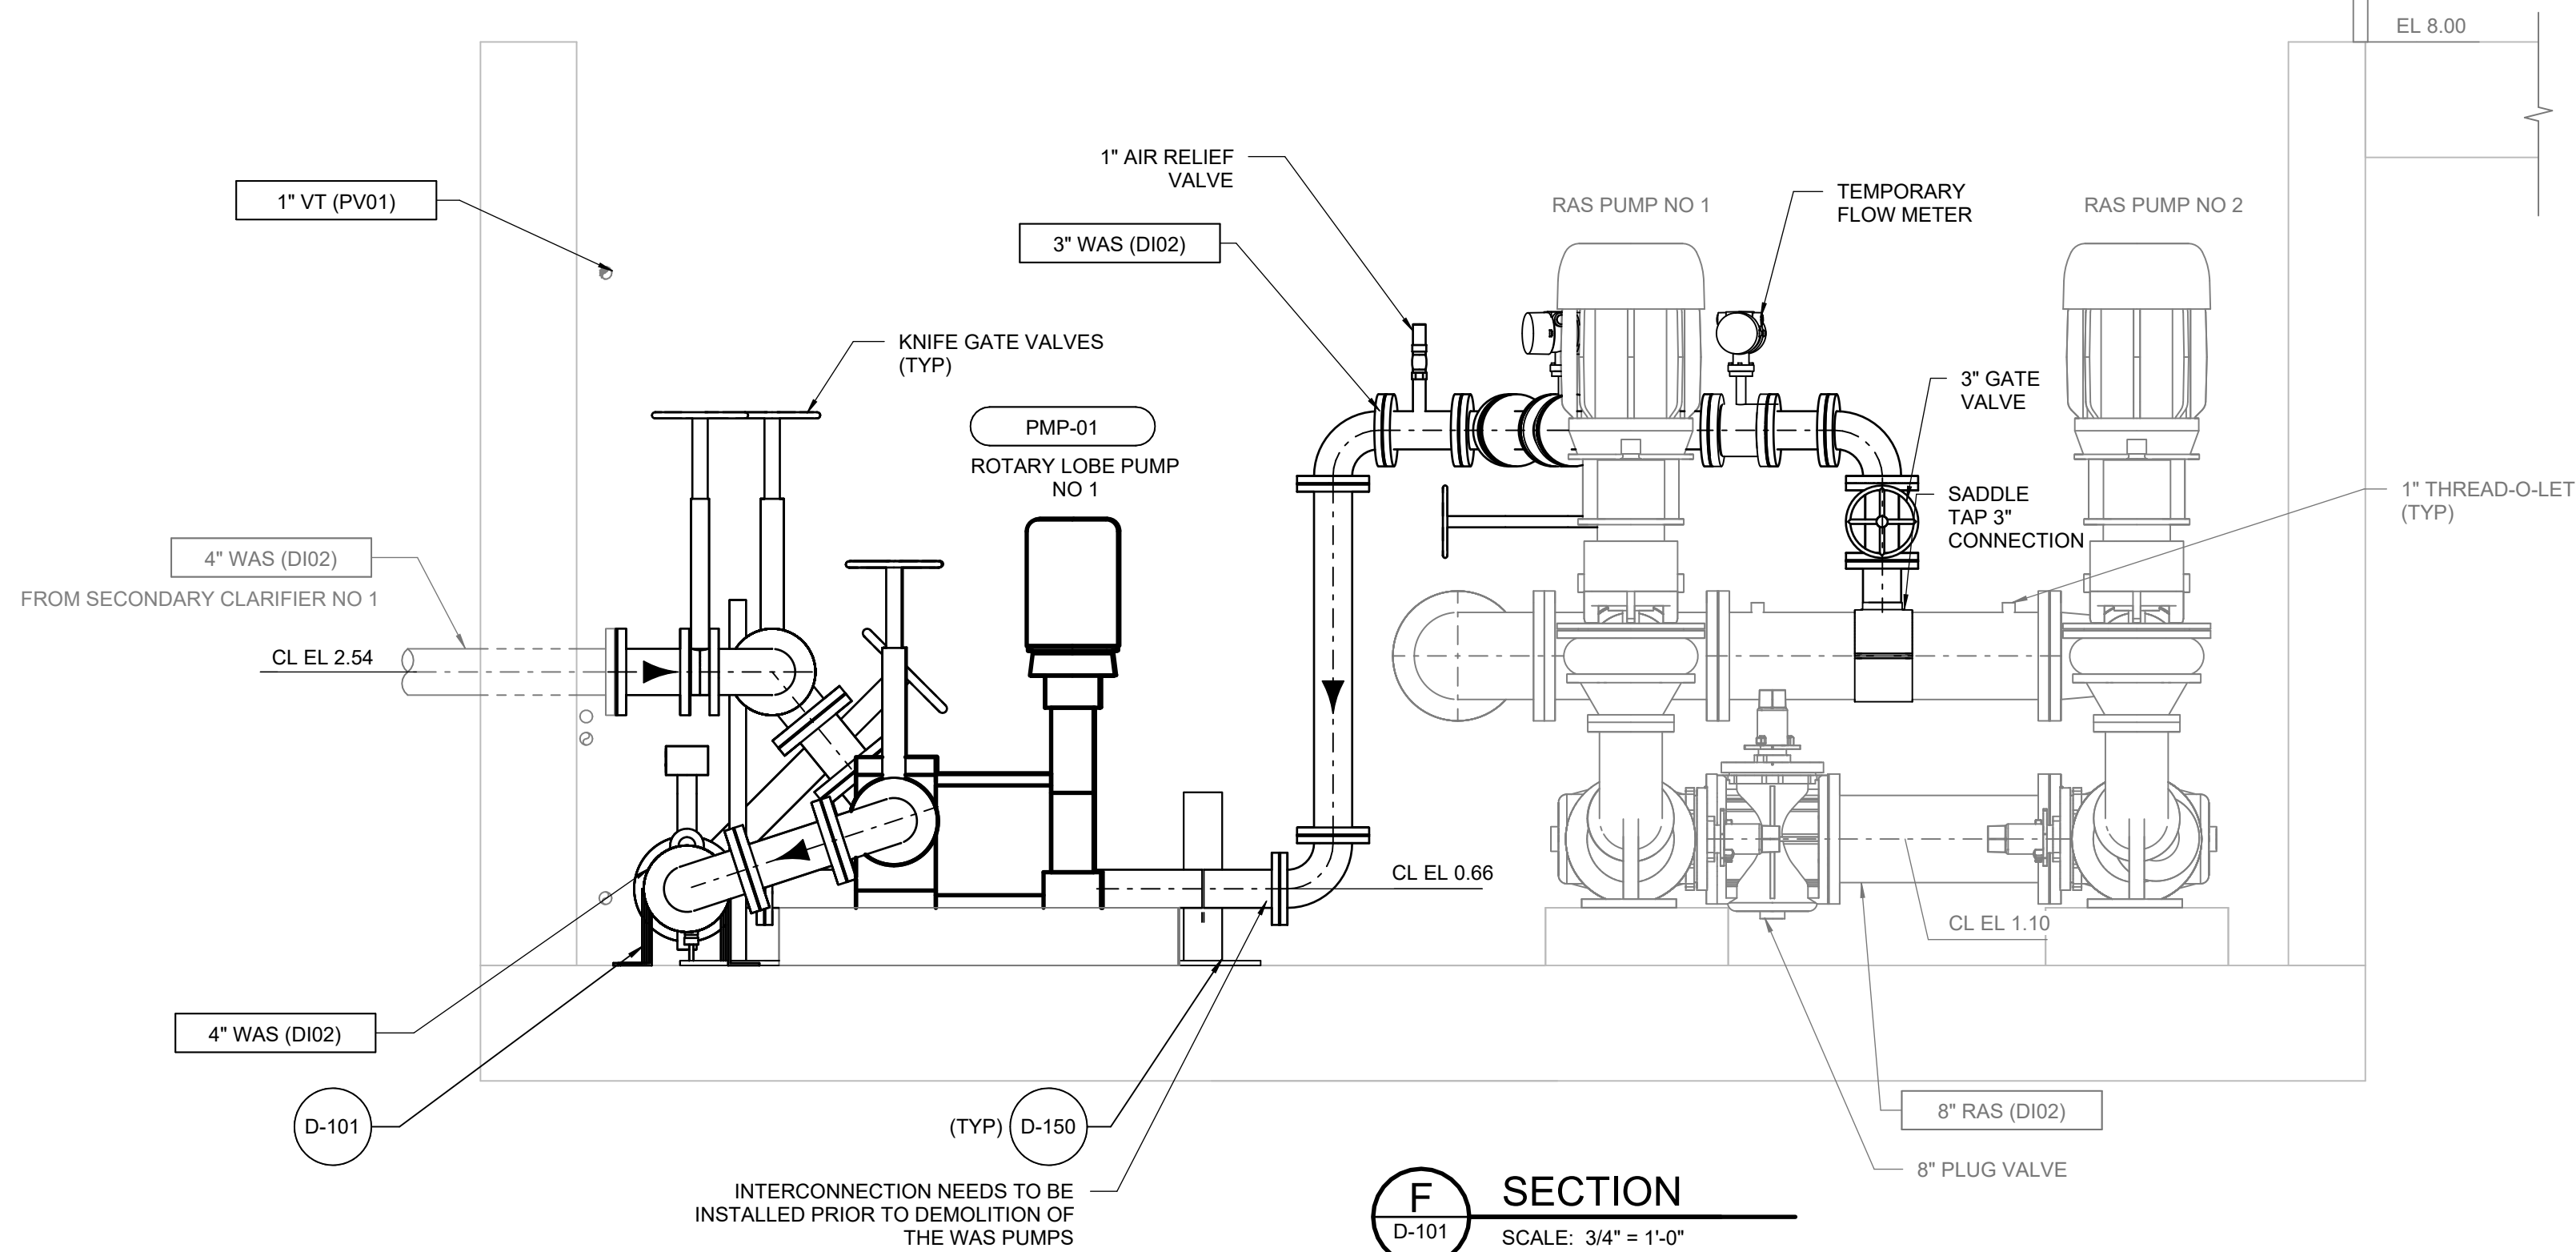

F SECTION
D-101 SCALE: 3/4" = 1'-0"

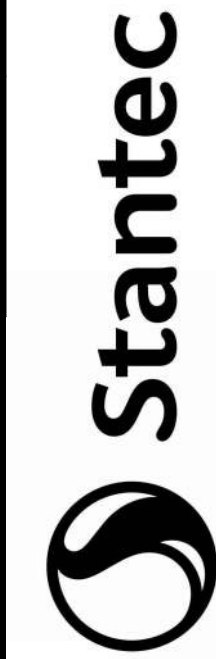


Stantec
601 SW 2nd Ave Suite 1400
Portland, Oregon, 97204
Tel: +1 503 226 7377
www.stantec.com

Consultant

Revision	By	Appd	YYYMMDD

Issued	By	Appd	YYYMMDD

Permit/Seal

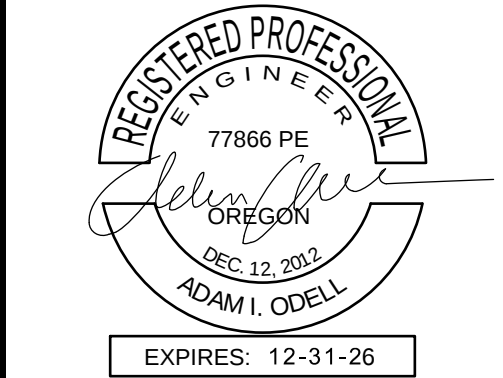

Client/Project
CITY OF SANDY
WASTE SLUDGE AND SCUM
PUMP REPLACEMENT
PROJECT
Sandy, OR


Project No.: 2002006370
File Name: 06370d-md.rvt
Scale: 3/4" = 1'-0"
Dwn. Dgn. Chkd. 2025.04.25
YYYYMMDD

Title
PUMP STATION
SECTIONS - II

Revision:
Drawing No.


D-302

C:\Users\j\OneDrive\Documents\Stantec\consulting\202006370_sandy_or\proj\files\work\01_sip\13_electrical\sheet_06370e-101.dwg
2025.05.18 2:03 AM

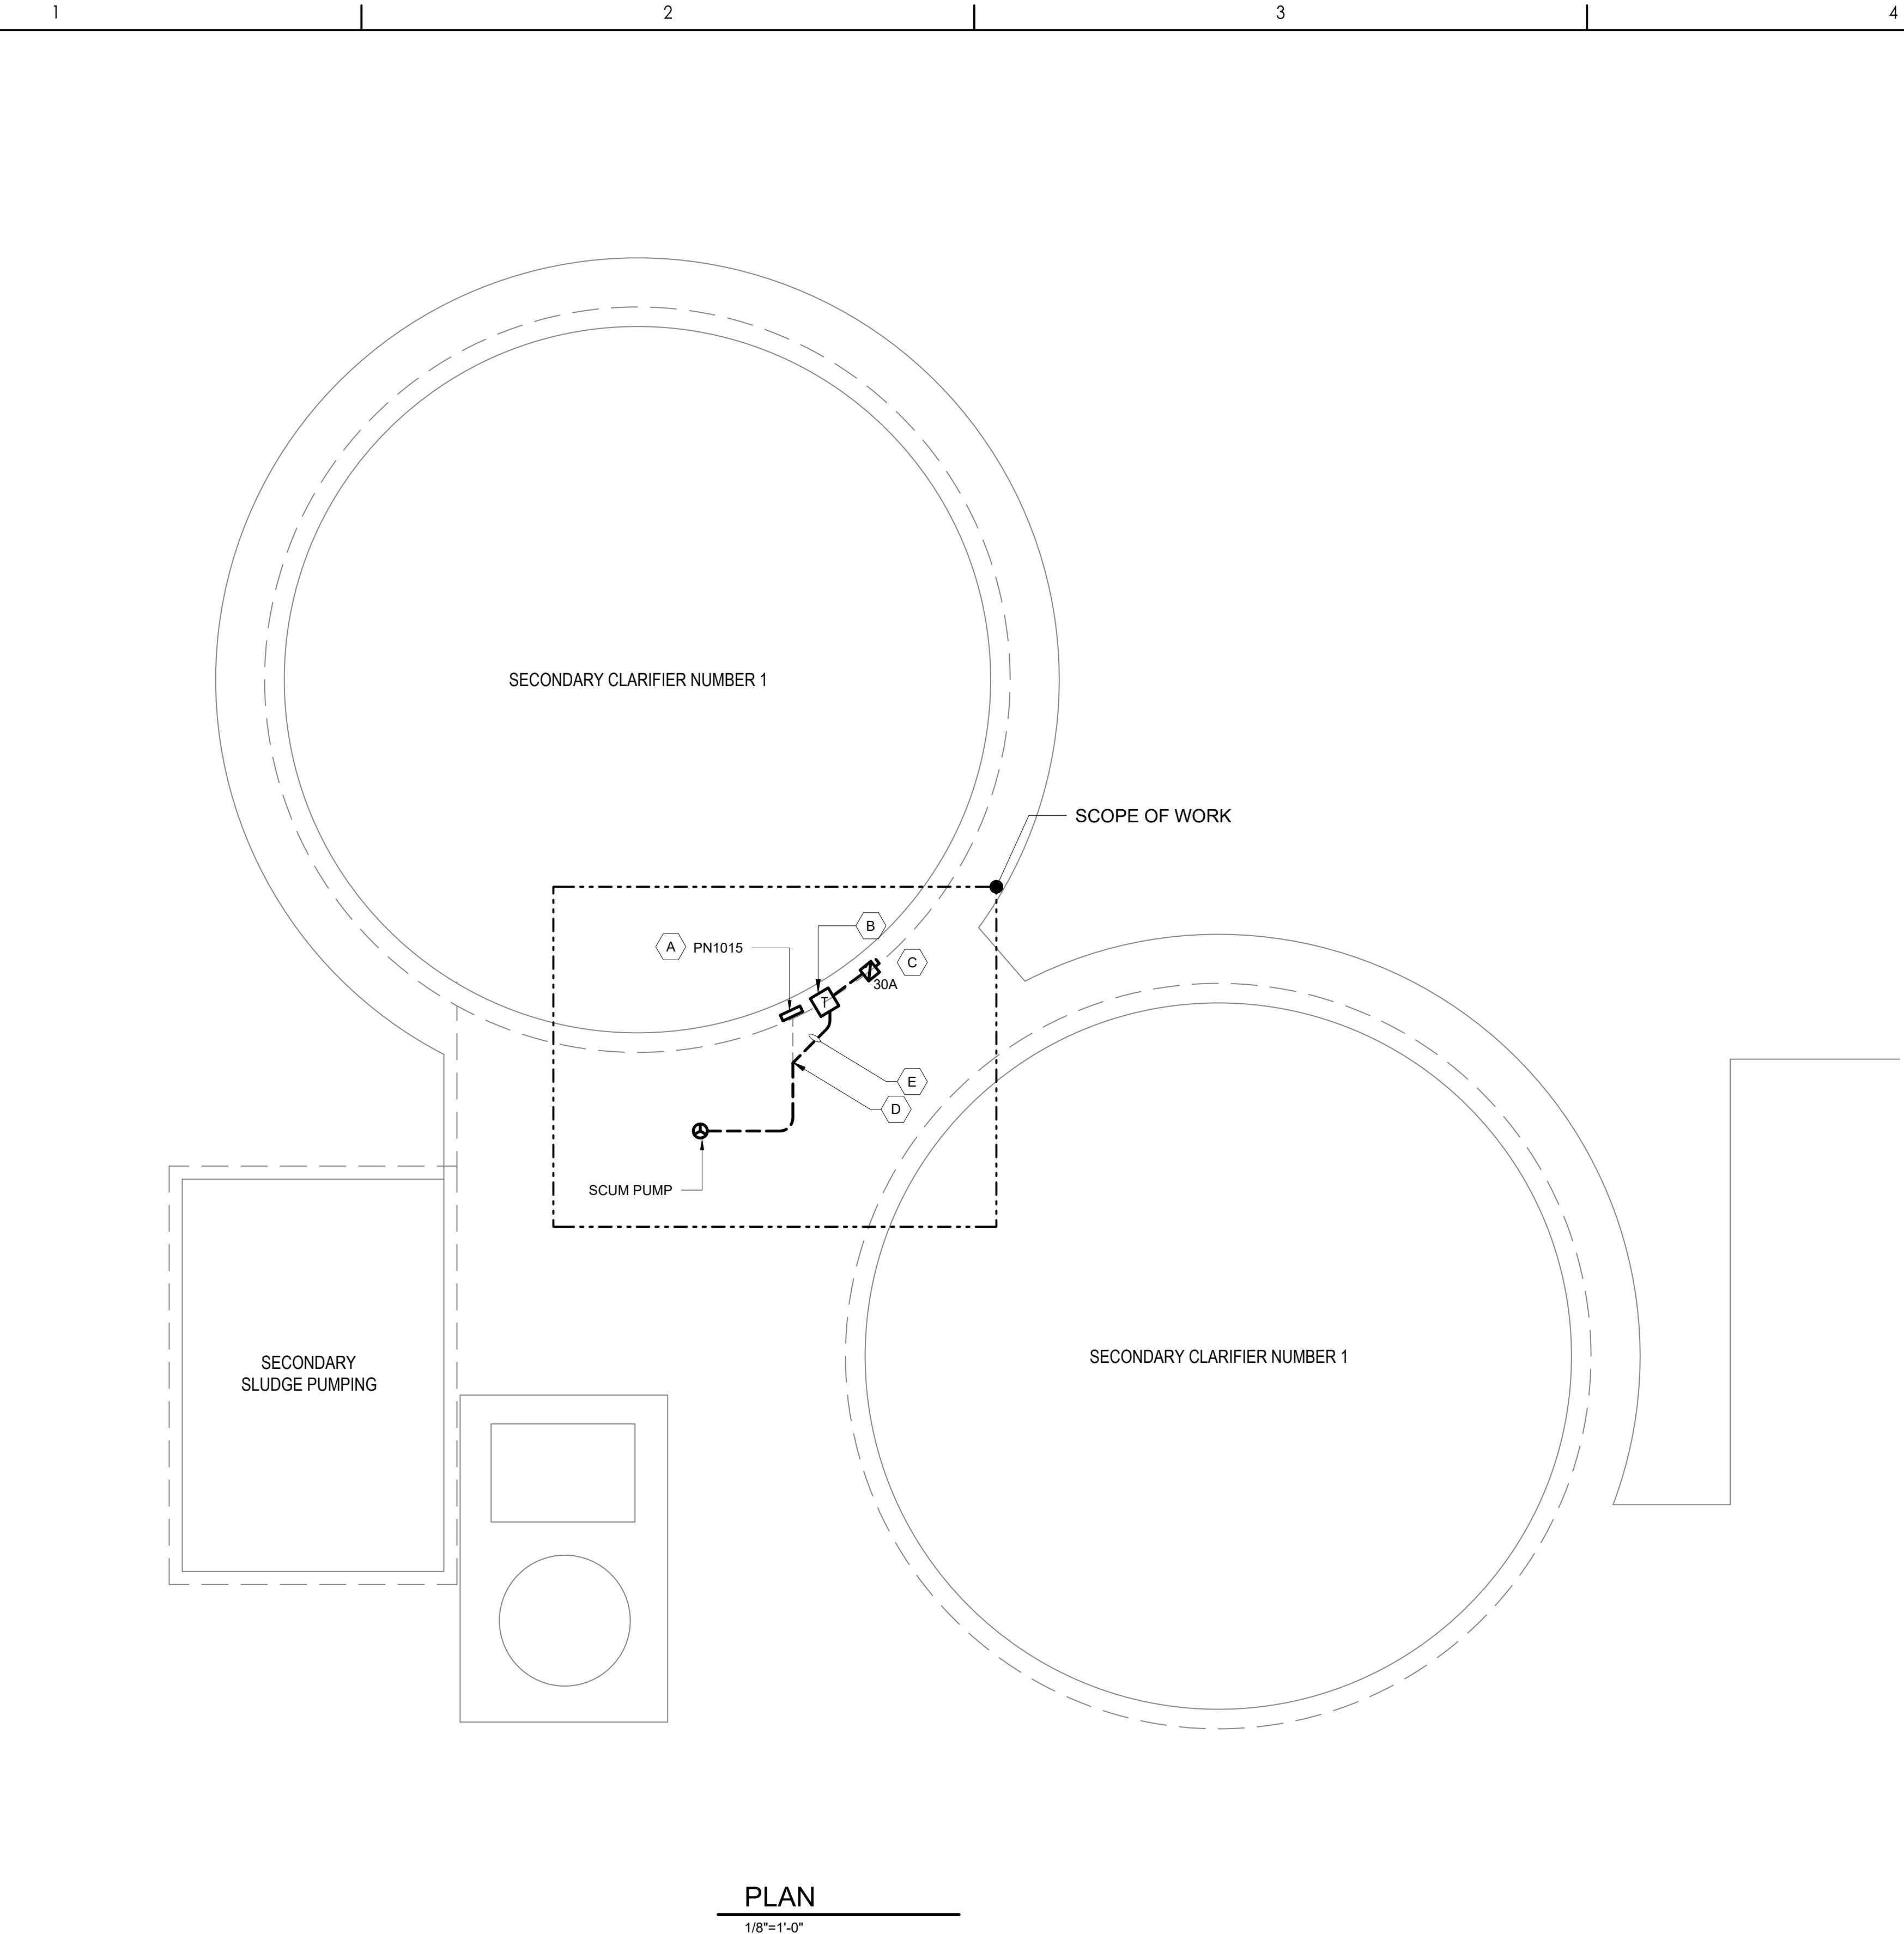


PLAN

1/8"=1'-0"

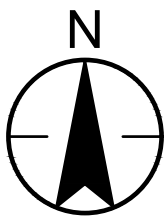

SHEET KEYNOTES

- A. DISCONNECT EXISTING 480V CIRCUIT TO EXISTING PUMP FROM PN-1015 AND RE-ROUTE TO TRANSFORMER.
- B. PROVIDE 6KVA NEMA 3R 480 TO 208Y/120V TRANSFORMER.
- C. PROVIDE 30A FUSED DISCONNECT.
- D. INTERCEPT EXISTING PATHWAY TO PUMP AND RE-ROUTE TO TRANSFORMER DISCONNECT. TERMINATE IN LOAD SIDE SEAL-OFFS.
- E. PROVIDE 3/4"C WITH 4#12 & #12G, TYP.

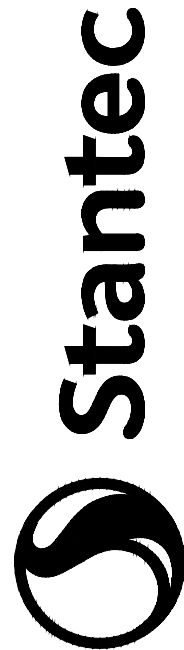

Stantec
601 SW 2nd Ave Suite 1400
Portland, Oregon 97204
Tel: Tel+1.503.226.7377
www.stantec.com

The Contractor shall verify and be responsible for all dimensions. DO NOT scale the drawing.
The Contractor shall verify and be responsible for all dimensions. DO NOT scale the drawing.
The Contractor shall verify and be responsible for all dimensions. DO NOT scale the drawing.
The Contractor shall verify and be responsible for all dimensions. DO NOT scale the drawing.

Consultant

Revision		By	Appd	YYYY.MM.DD

Issued		By	Appd	YYYY.MM.DD

Permit/Seal



EXPIRES 06-30-2026

Client/Project
CITY OF SANDY

WASTE SLUDGE AND
SCUM PUMP
REPLACEMENT PROJECT

Sandy, OR

Project No.: 2002006370

File Name: 06370E-101


Scale: 1/8"=1'-0"

JL	WS	2025.XX.XX
Dwn.	Dsgn.	Chkd.

Title
SITE PLAN


Revision: Sheet: of XX
Drawing No.

 E-101



1

- Consultant

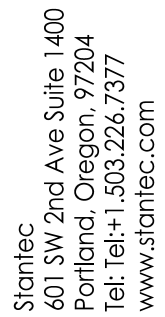

The Contractor shall verify and be responsible for all dimensions. DO NOT scale the drawing - any errors or omissions shall be reported to Stantec without delay. The Copyrights to all designs and drawings are the property of Stantec. Reproduction or use for any purpose other than that authorized by Stantec is forbidden.

[illegible][illegible]

EXPIRES	06-30-2026
---------	------------

WASTE SLUDGE AND
SCUM PUMP
REPLACEMENT PROJECT
Sandy, OR

JL	WS	2025.XX.XX
Dwn.	Dsgn.	Chkd.
		YYYY.MM.DD

Drawing No.

E 102

E-102